




PLAN
1"=20"

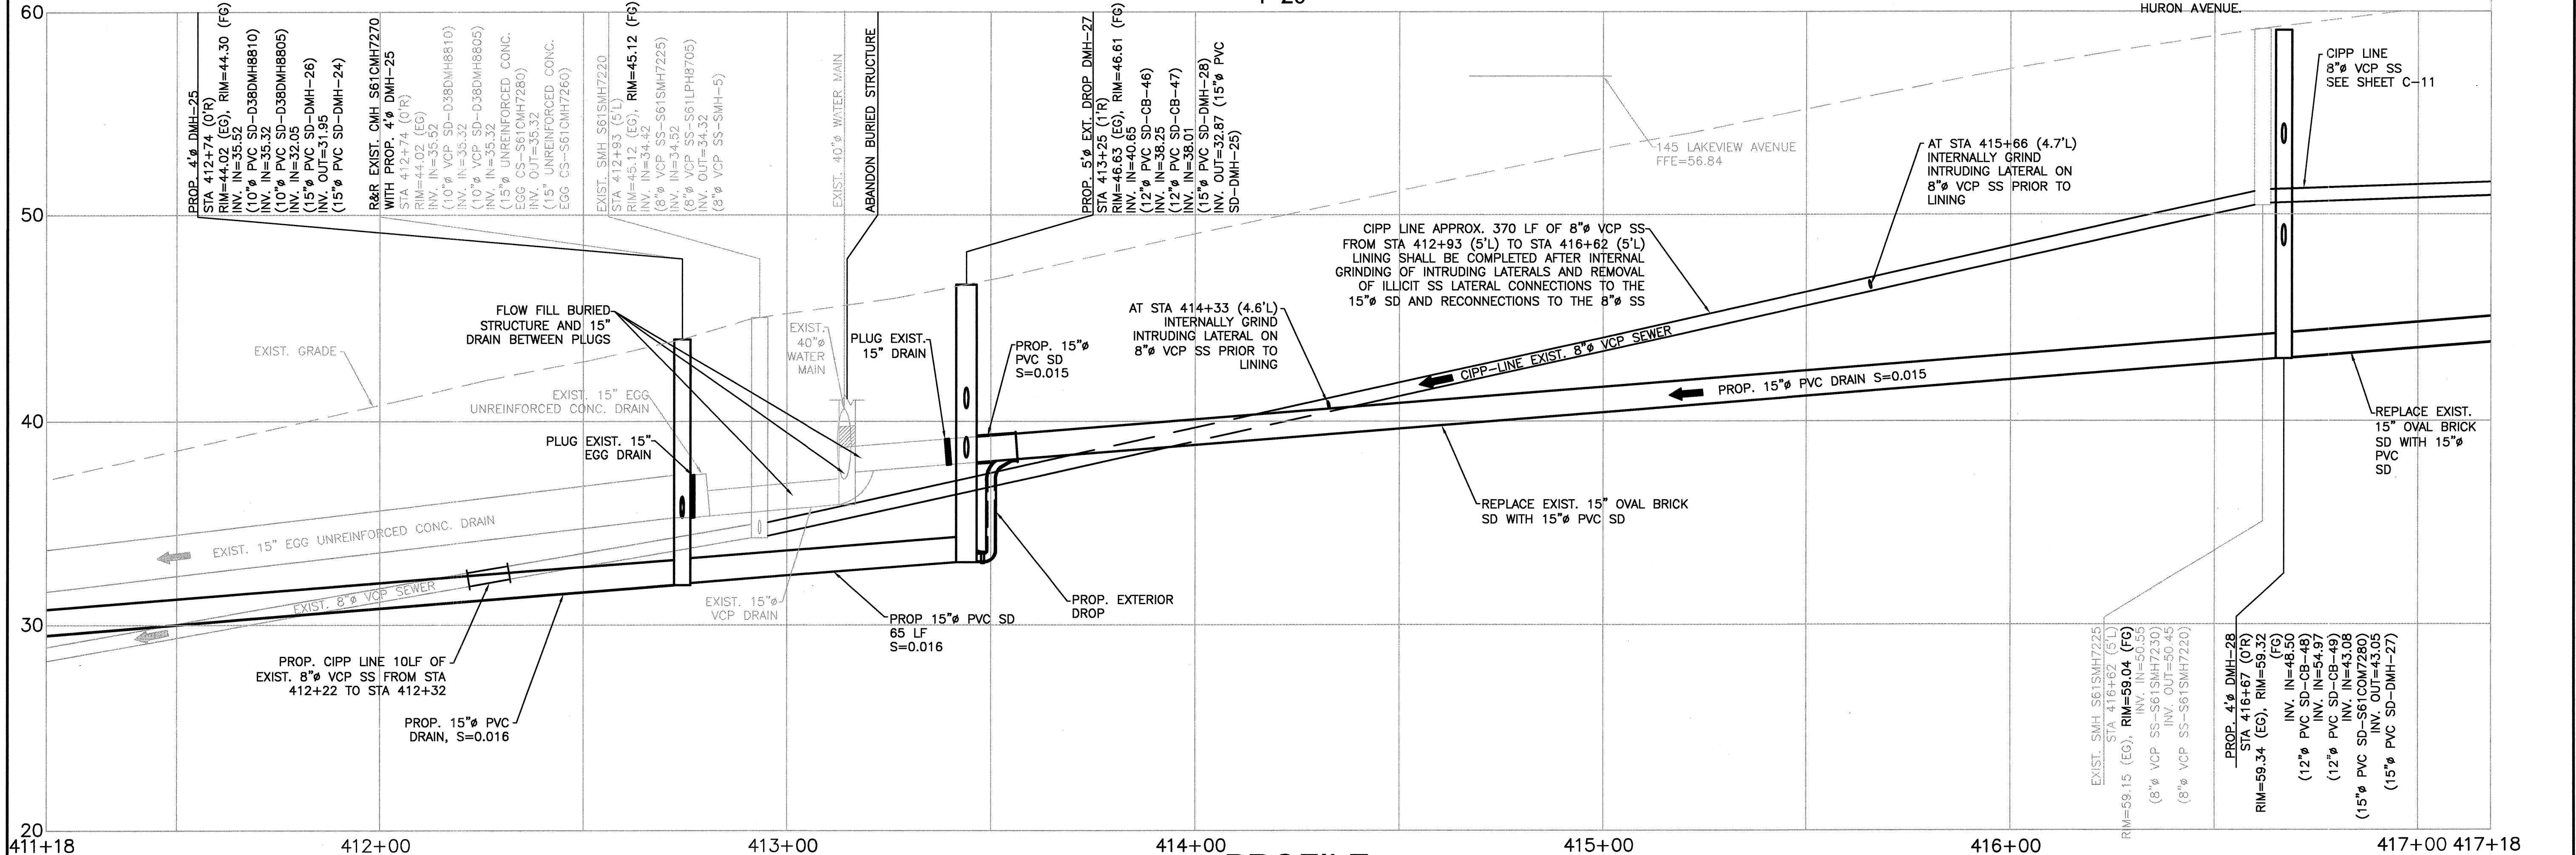

PROFILE
HORIZONTAL SCALE: 1"=20"
VERTICAL SCALE: 1"=4'

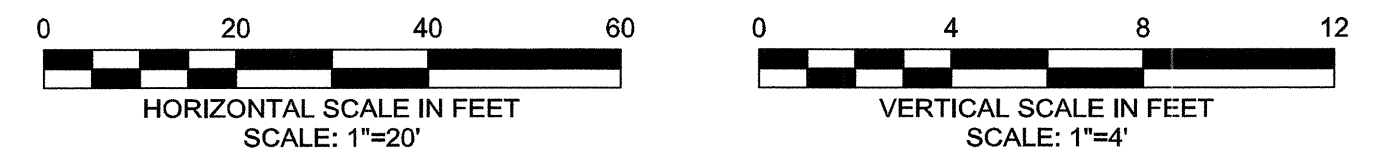

CONFORMED SET

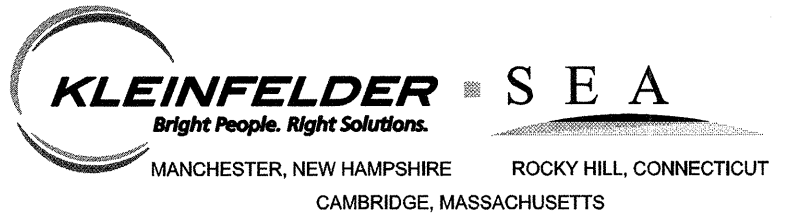


Scale	AS NOTED	Date	SEPTEMBER 2012	Job No.	1010691	Designed by	AMF	Drawn by	ZSH	Checked by	BFR	No.	Description	Date	Approved by	AMF
REVISIONS																




CITY OF CAMBRIDGE, MASSACHUSETTS
HURON A SEWER SEPARATION PROJECT
 CONTRACT NO. 8A
 CIVIL - PLAN AND PROFILE FOR AREA III ON
 LAKEVIEW AVENUE STA 411+18 TO STA 417+18


Sheet No. **C-10**
 File No.

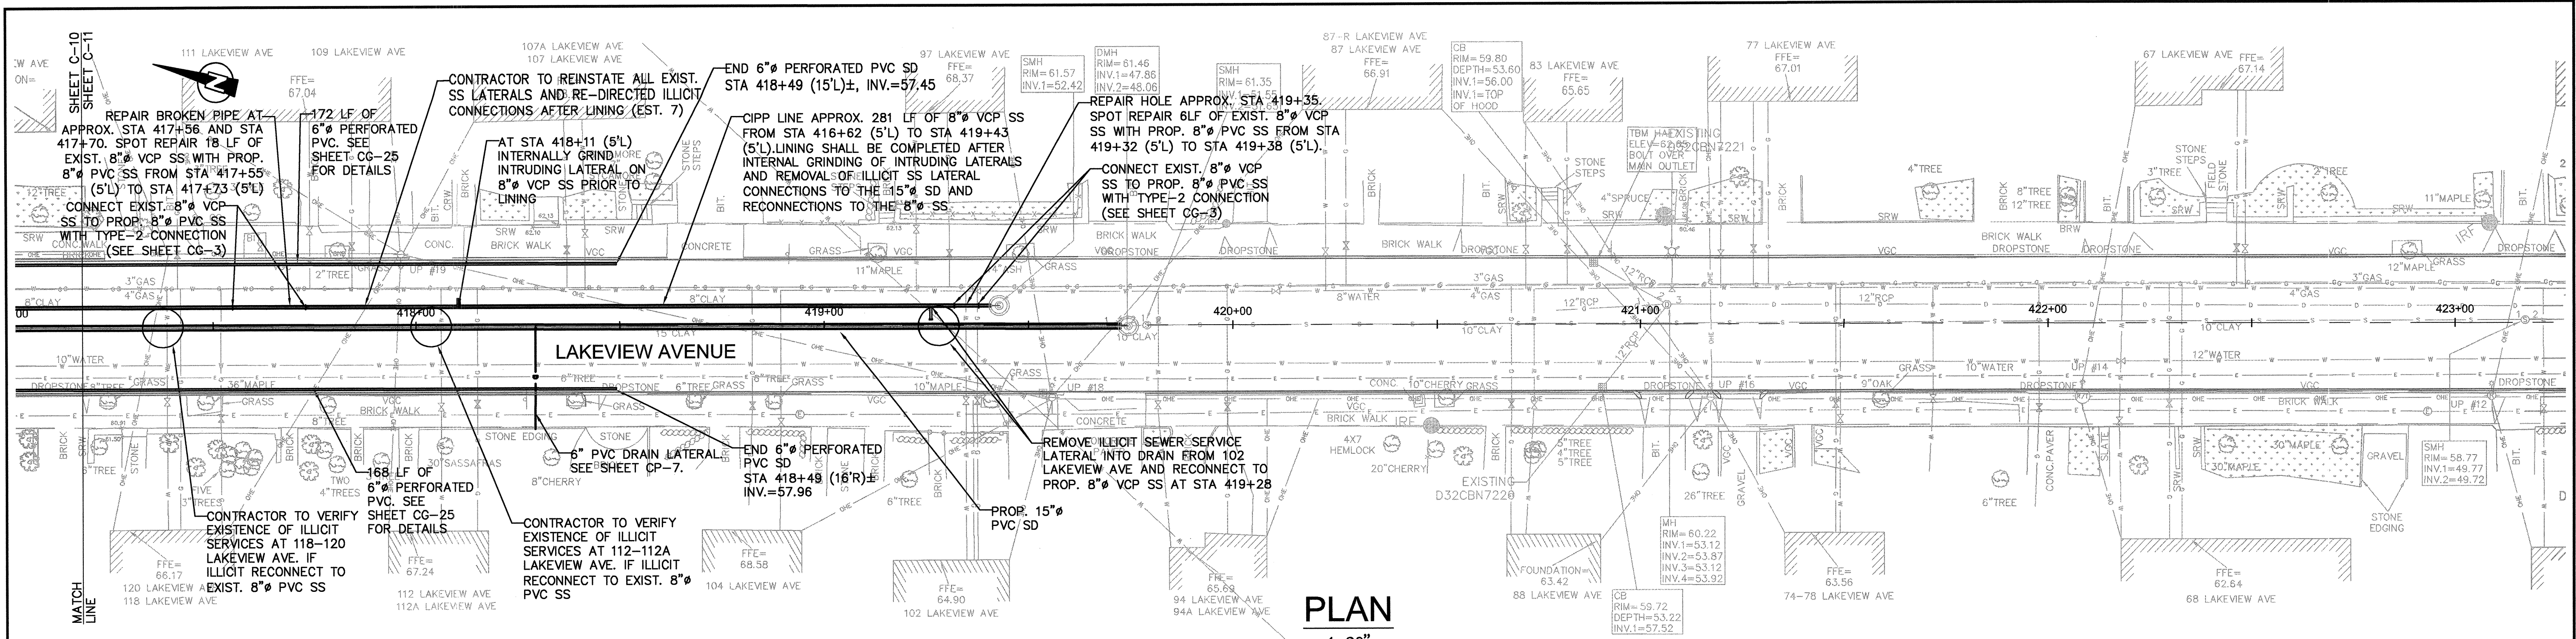



PLAN
1"=20"

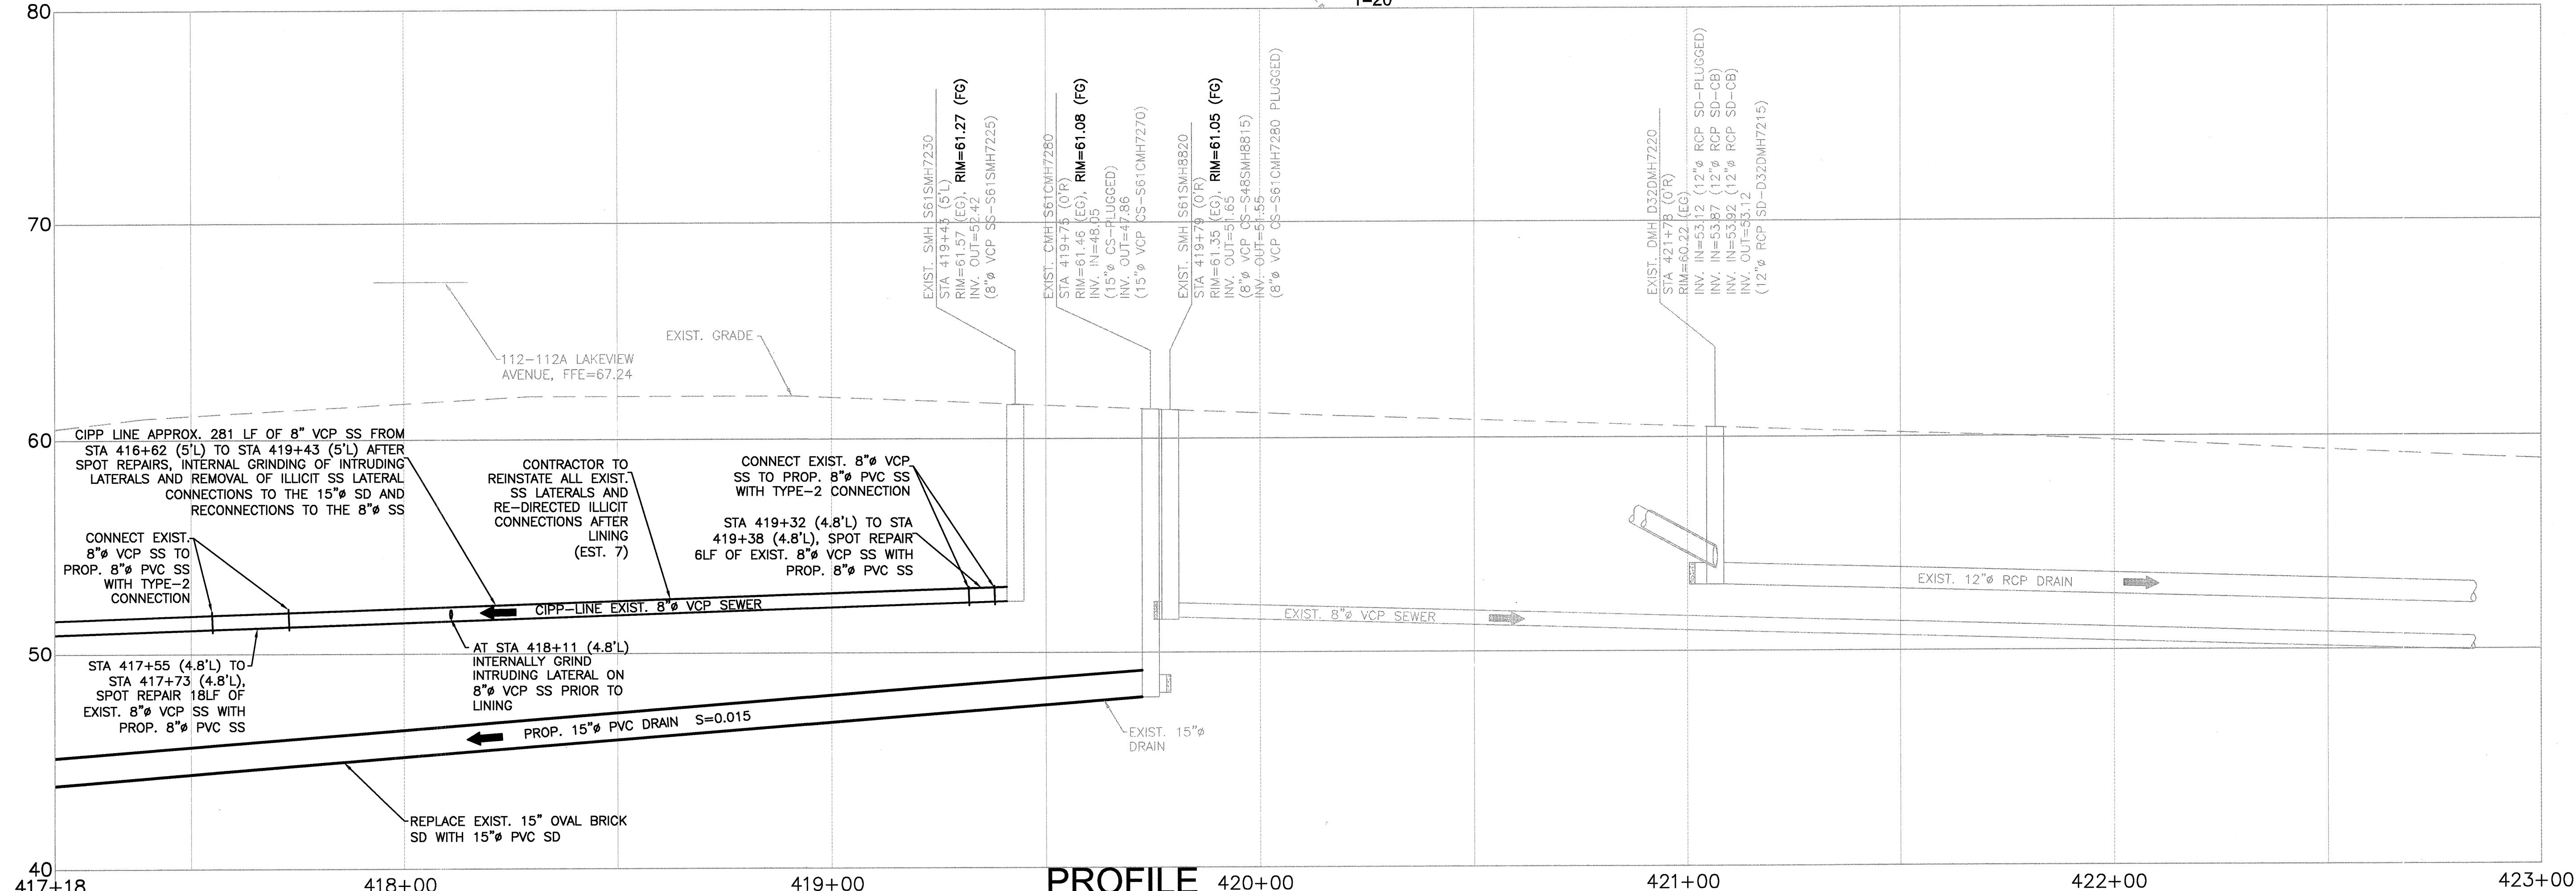

PROFILE
HORIZONTAL SCALE: 1"=20"
VERTICAL SCALE: 1"=4'

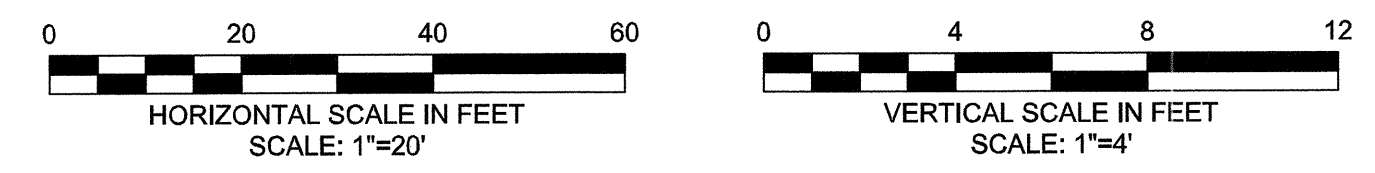

CONFORMED SET

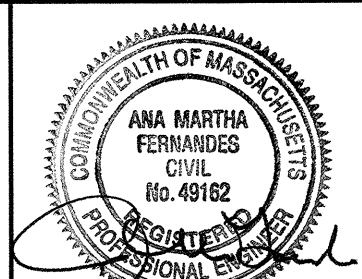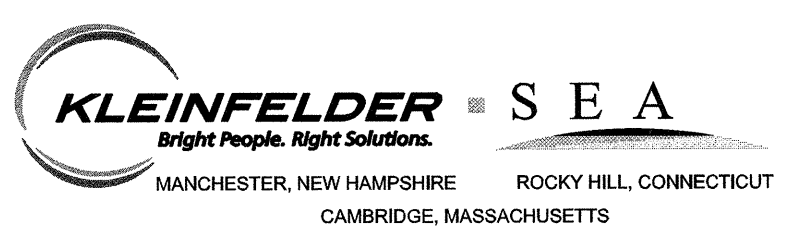


Scale	AS NOTED			
Date	SEPTEMBER 2012			
Job No.	1010691			
Designed by	AMF			
Drawn by	ZSH			
Checked by	BFR	No.	Description	Date
Approved by	AMF		REVISIONS	




CITY OF CAMBRIDGE, MASSACHUSETTS
 HURON A SEWER SEPARATION PROJECT
 CONTRACT NO. 8A
 CIVIL - PLAN AND PROFILE FOR AREA IV ON
 LAKEVIEW AVENUE STA 417+18 TO STA 423+00

Sheet No.
C-11
File No.

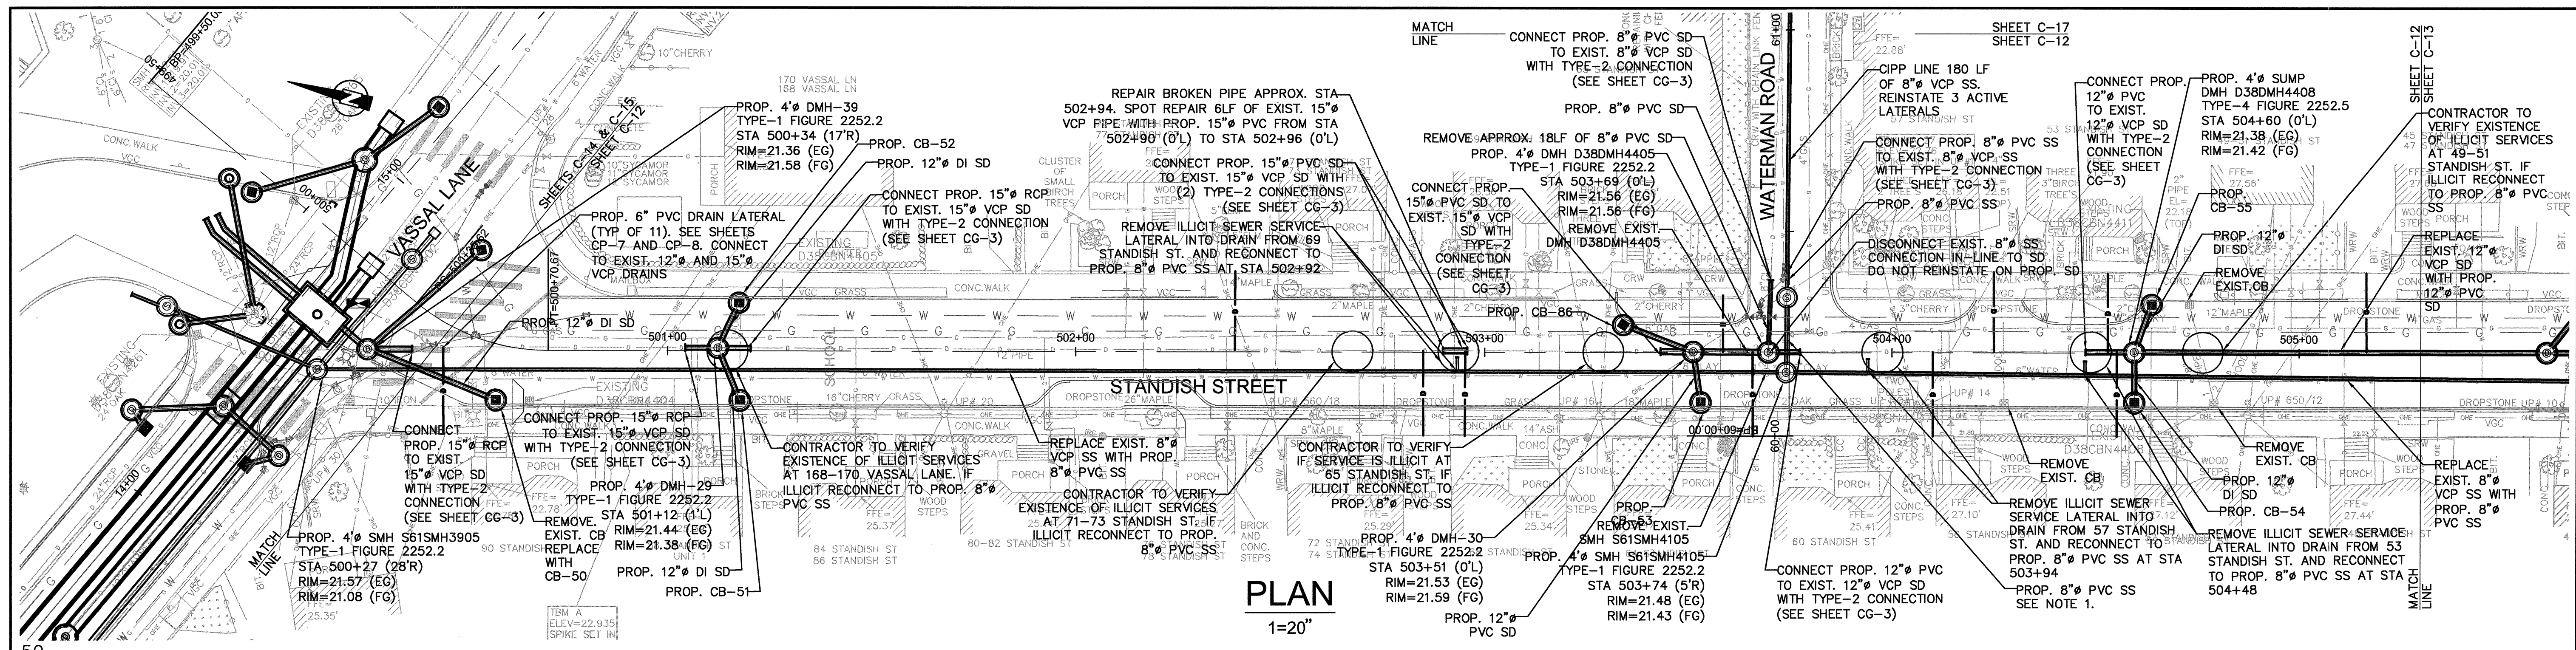

PLAN
1"=20'

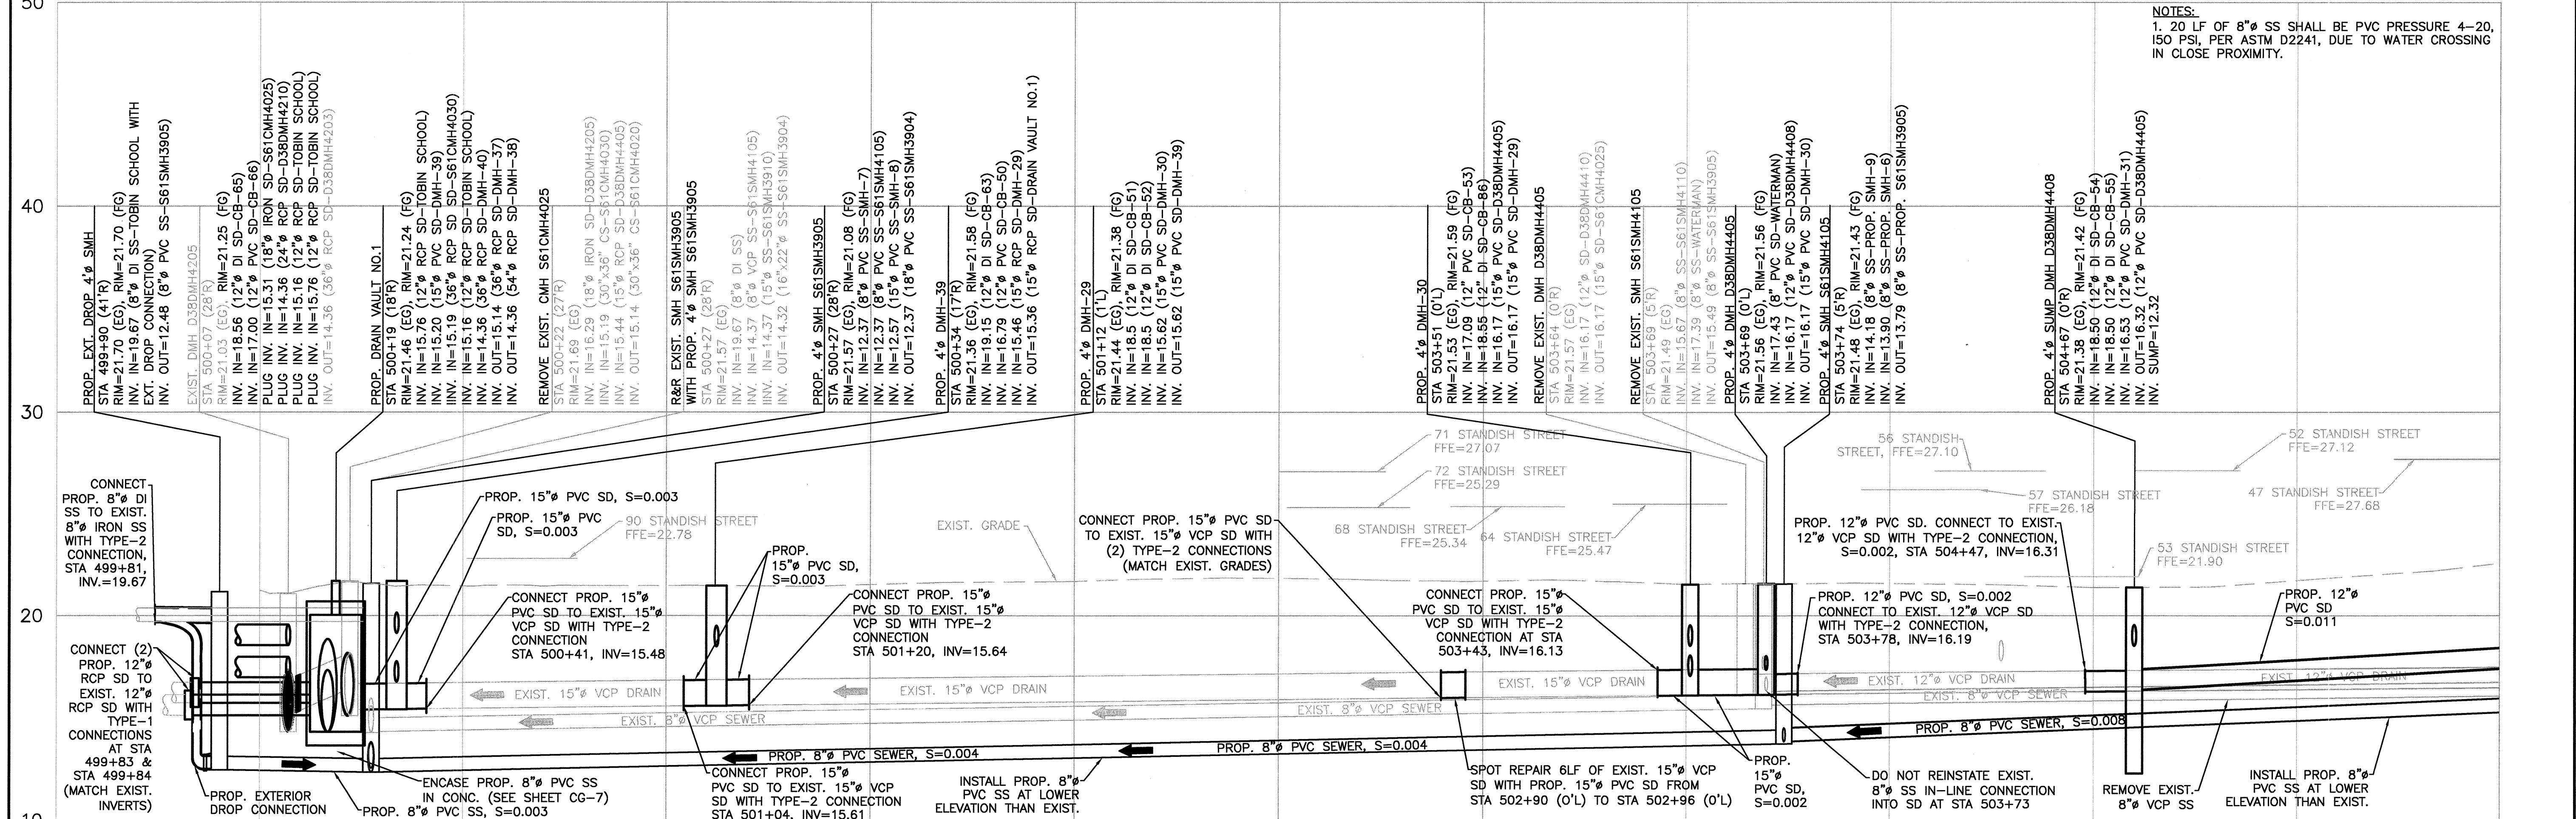

PROFILE
HORIZONTAL SCALE: 1"=20'
VERTICAL SCALE: 1"=4'

NOTES:
1. 20 LF OF 8" SS SHALL BE PVC PRESSURE 4-20, 150 PSI, PER ASTM D2241, DUE TO WATER CROSSING IN CLOSE PROXIMITY.






Scale	AS NOTED			
Date	SEPTEMBER 2012			
Job No.	1010691			
Designed by	AMF			
Drawn by	ZSH			
Checked by	BFR	No.	Description	Date
Approved by	AMF		REVISIONS	




CITY OF CAMBRIDGE, MASSACHUSETTS
 HURON A SEWER SEPARATION PROJECT
 CONTRACT NO. 8A
 CIVIL - PLAN AND PROFILE FOR AREA I ON
 STANDISH STREET STA 499+50 TO STA 505+50


Sheet No. **C-12**
 File No.

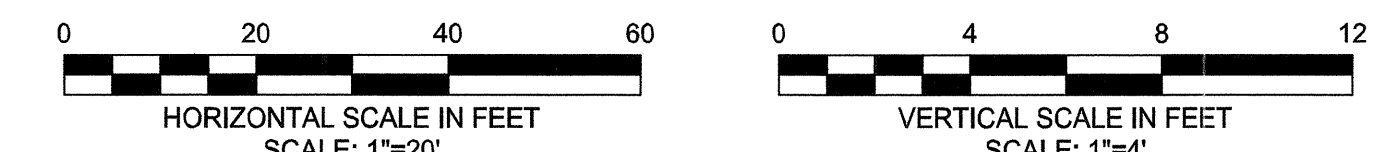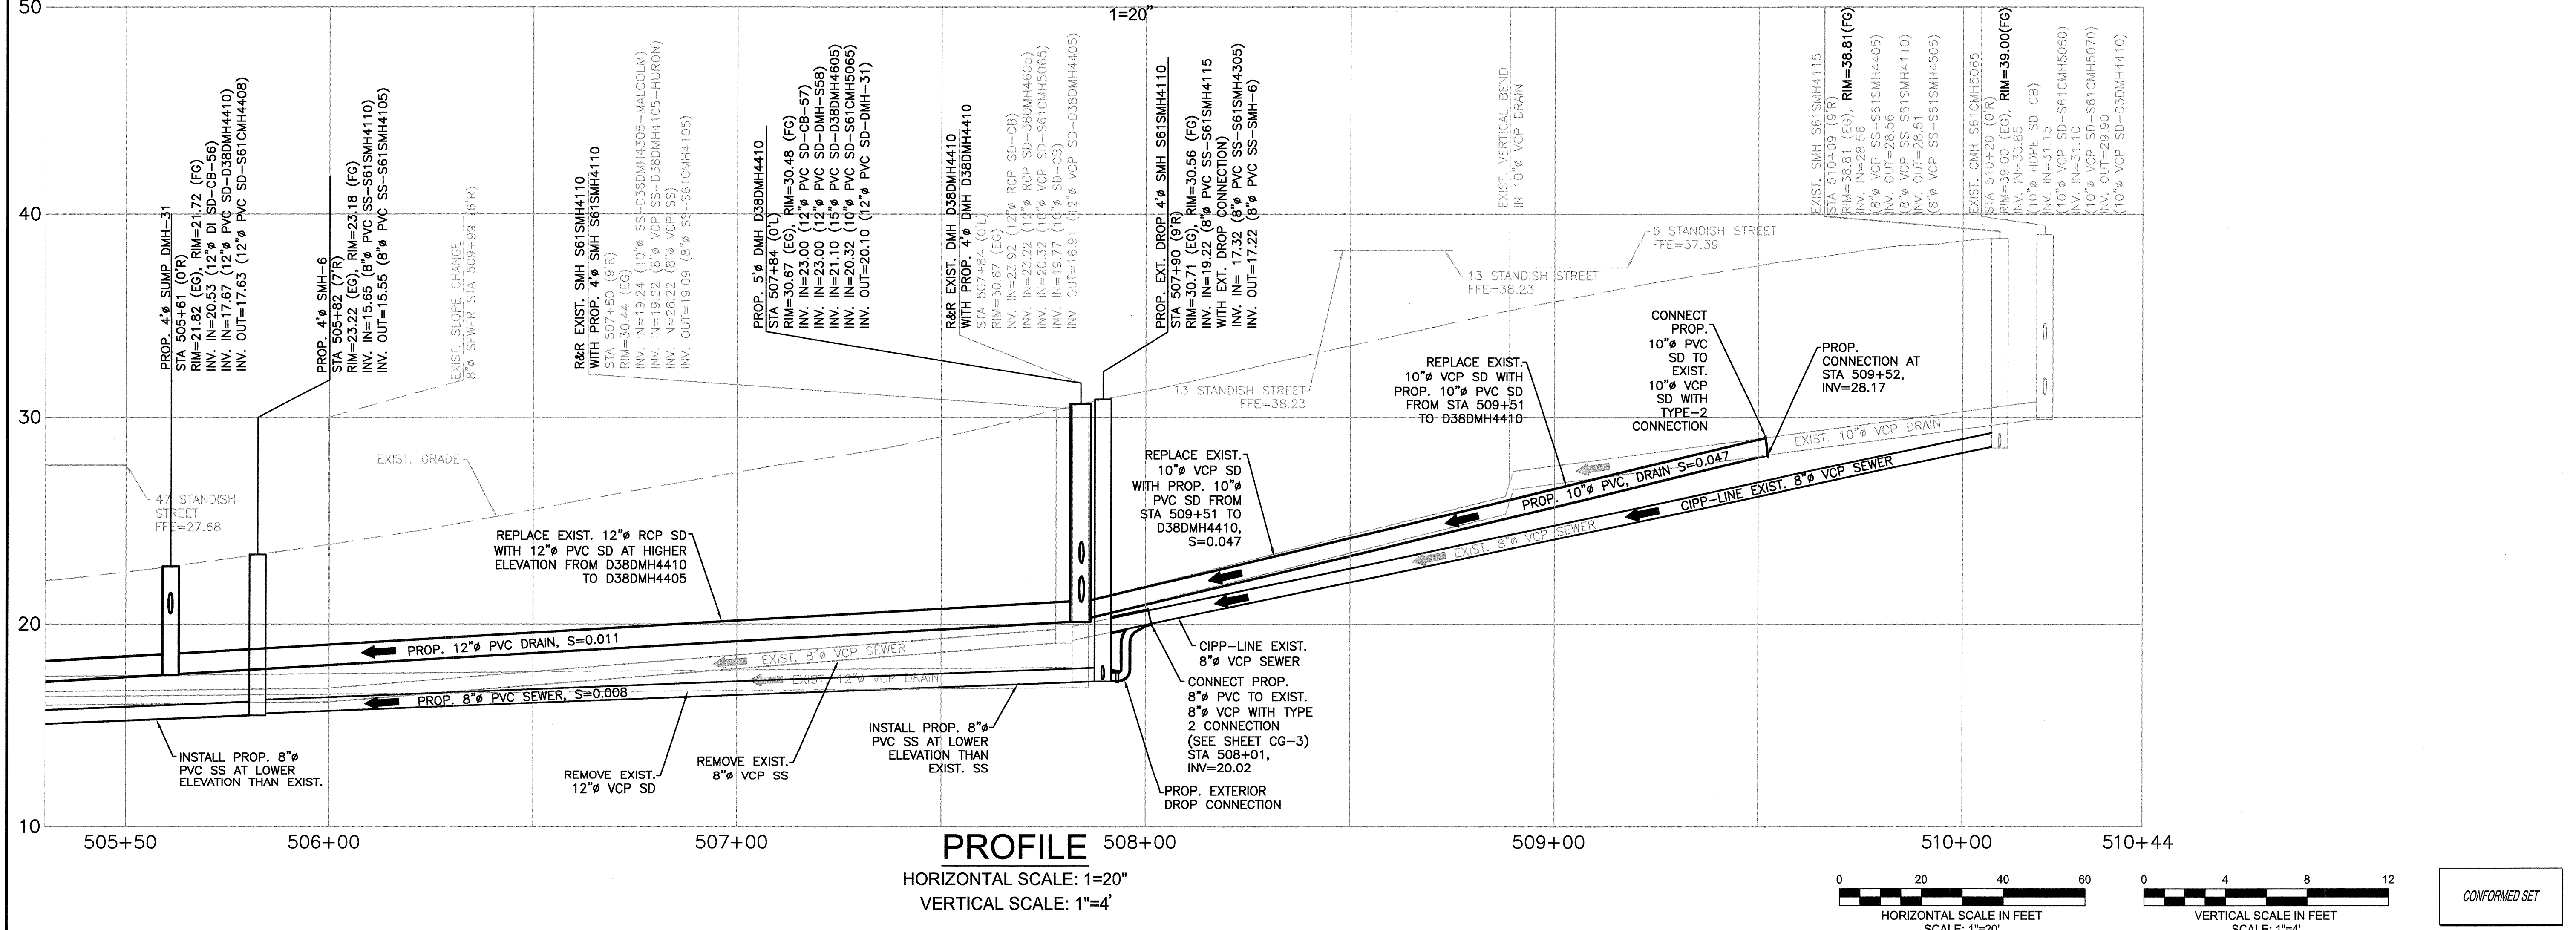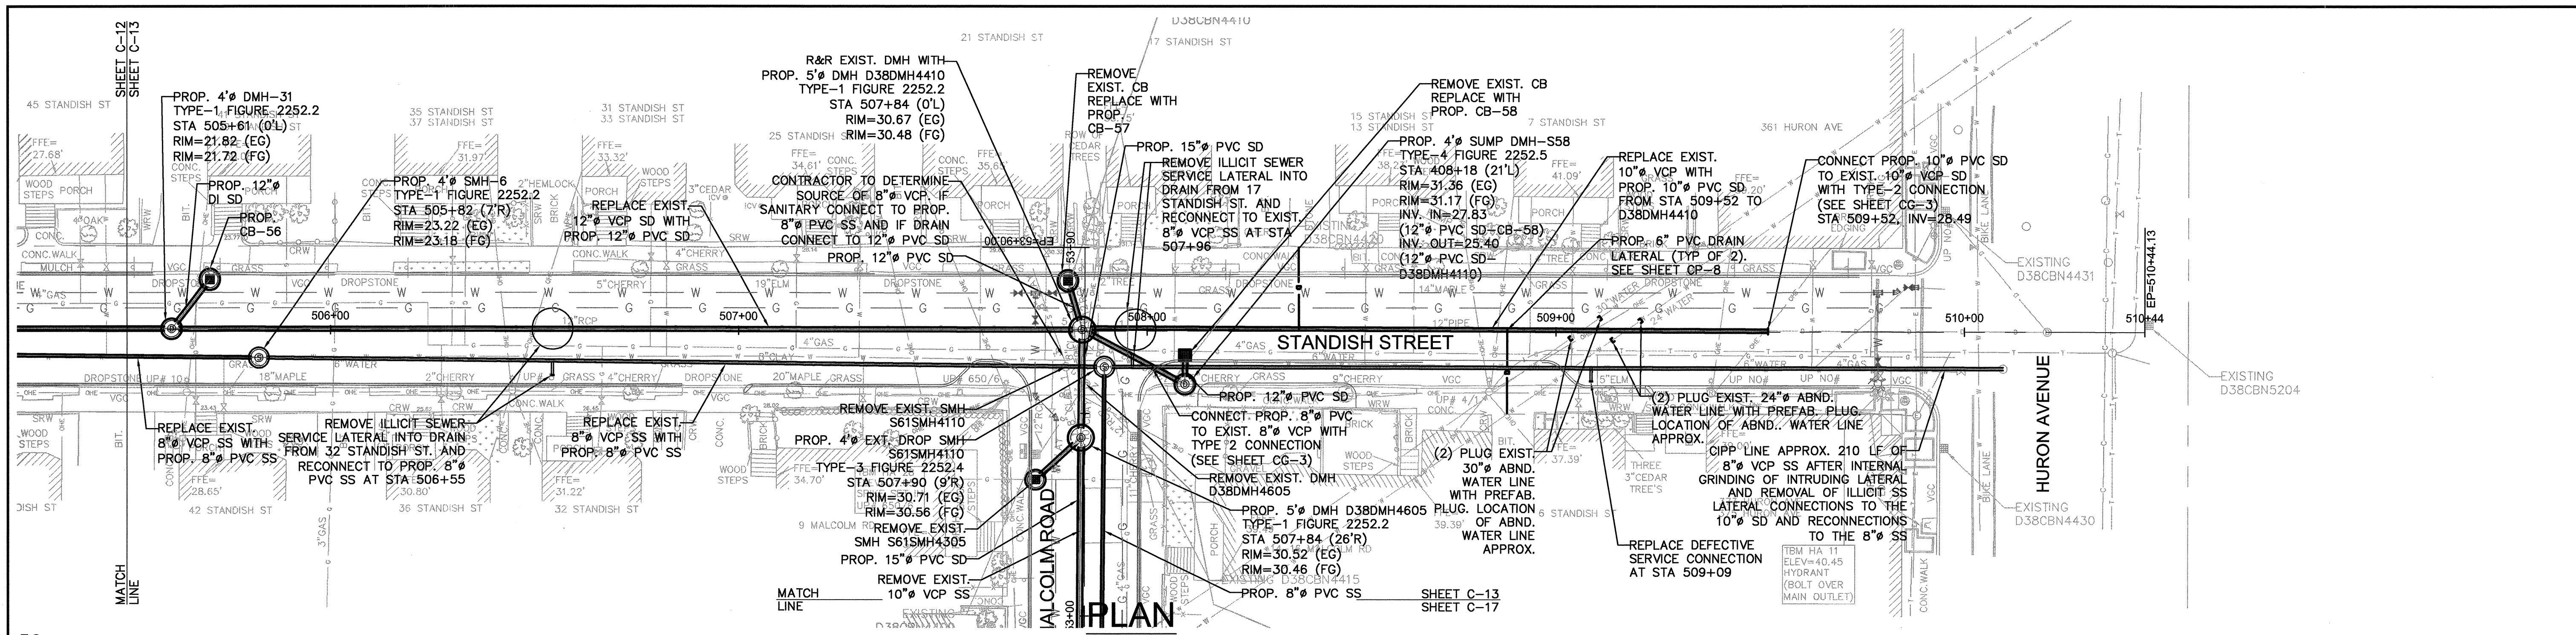

CONFIRMED SET


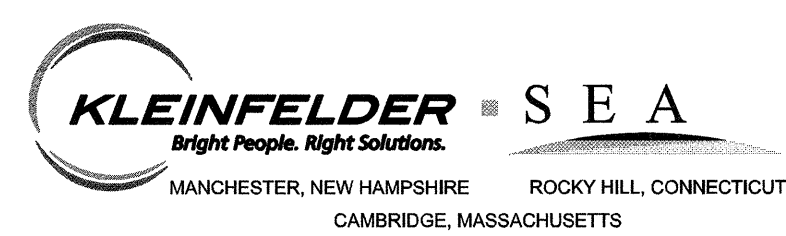


Scale	AS NOTED		
Date	SEPTEMBER 2012		
Job No.	1010691		
Designed by	AMF		
Drawn by	ZSH		
Checked by	BFR	No.	Description
Approved by	AMF		Date

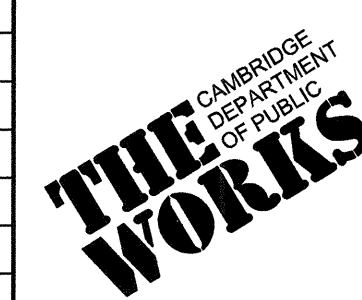


CITY OF CAMBRIDGE, MASSACHUSETTS
 HURON A SEWER SEPARATION PROJECT
 CONTRACT NO. 8A
 CIVIL - PLAN AND PROFILE FOR AREA II ON
 STANDISH STREET STA 505+30 TO STA 510+44

Sheet No. **C-13**
 File No.

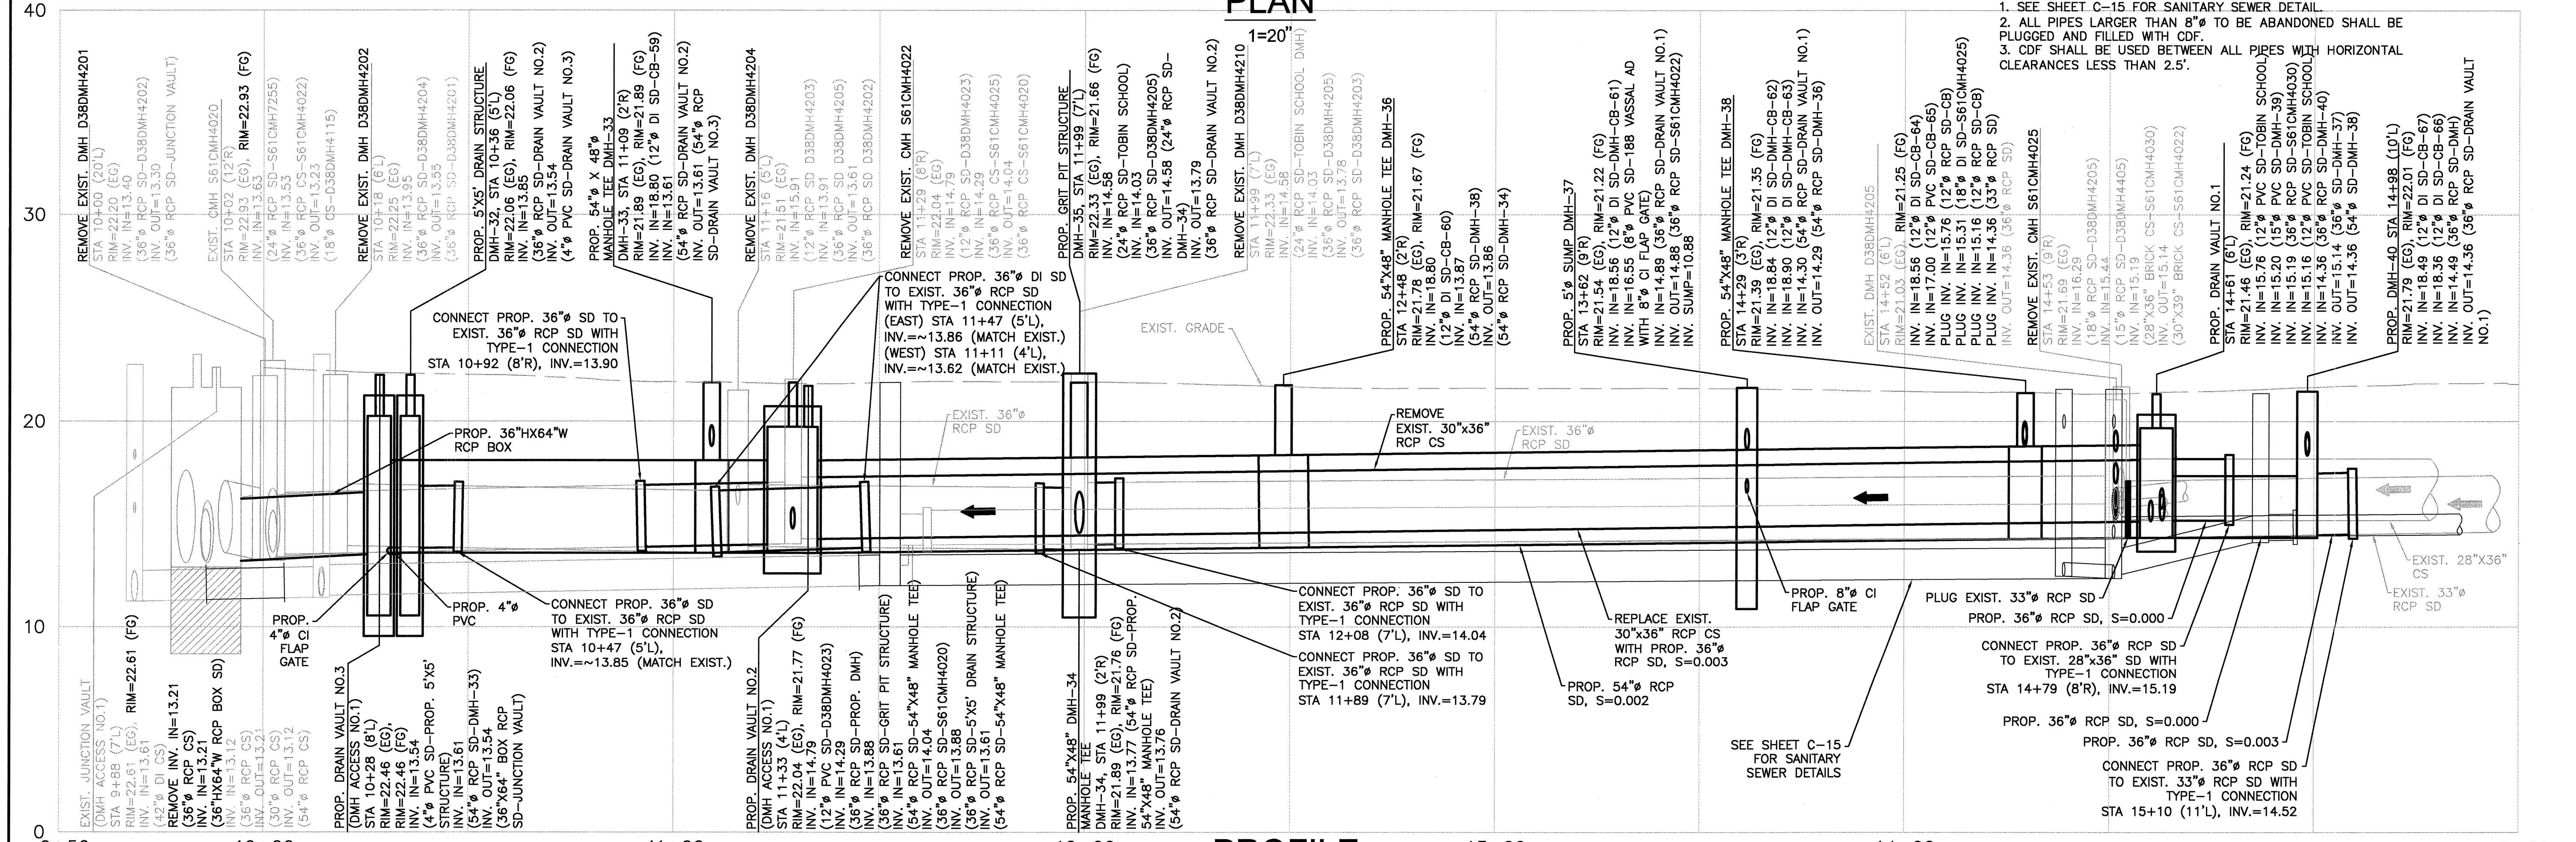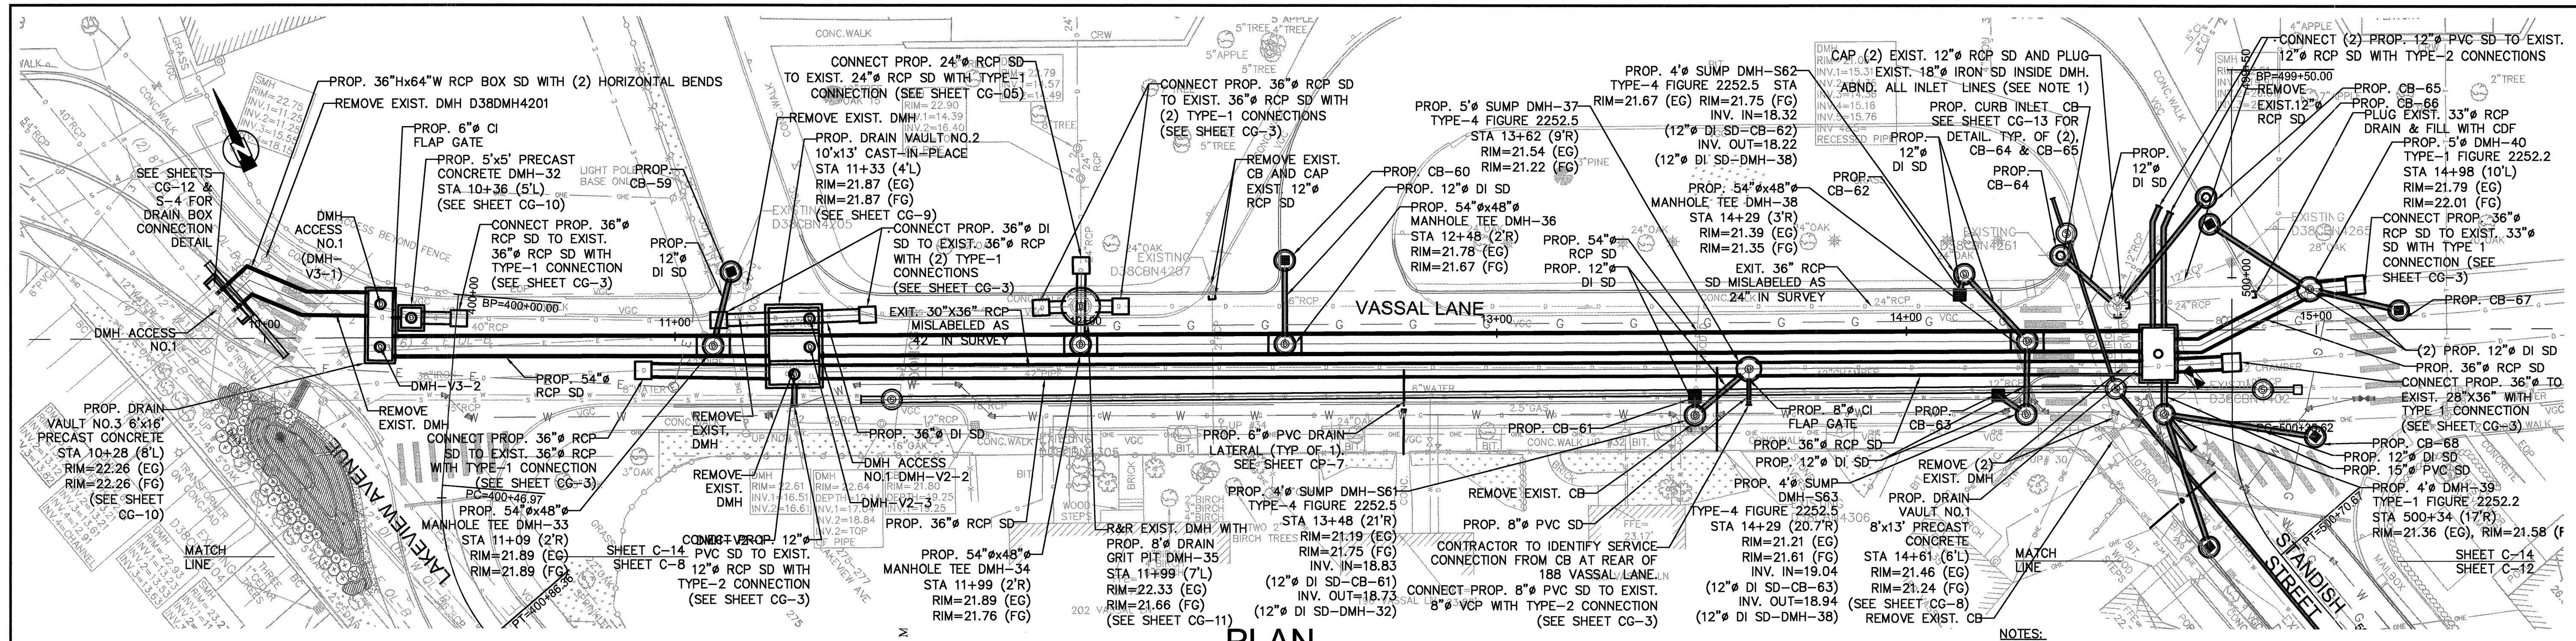


PROFILE

HORIZONTAL SCALE: 1"=20'
VERTICAL SCALE: 1"=4'

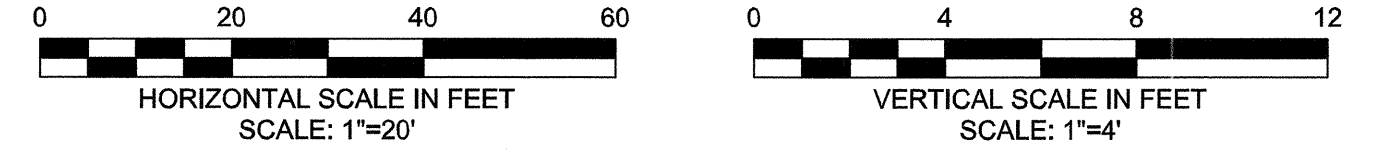

CONFORMED SET

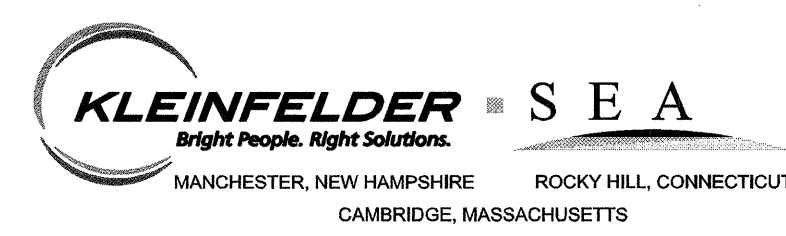


Scale	AS NOTED	Date	SEPTEMBER 2012
Job No.	1010691	Designed by	AMF
Drawn by	ZSH	Checked by	BFR
Approved by	AMF	No.	
		Description	REVISIONS
		Date	




CITY OF CAMBRIDGE, MASSACHUSETTS
HURON A SEWER SEPARATION PROJECT
CONTRACT NO. 8A
CIVIL - PLAN AND PROFILE FOR VASSAL LANE
STORM DRAIN (PROFILE I) STA 9+50 TO STA 15+50

Sheet No. **C-14**
File No.

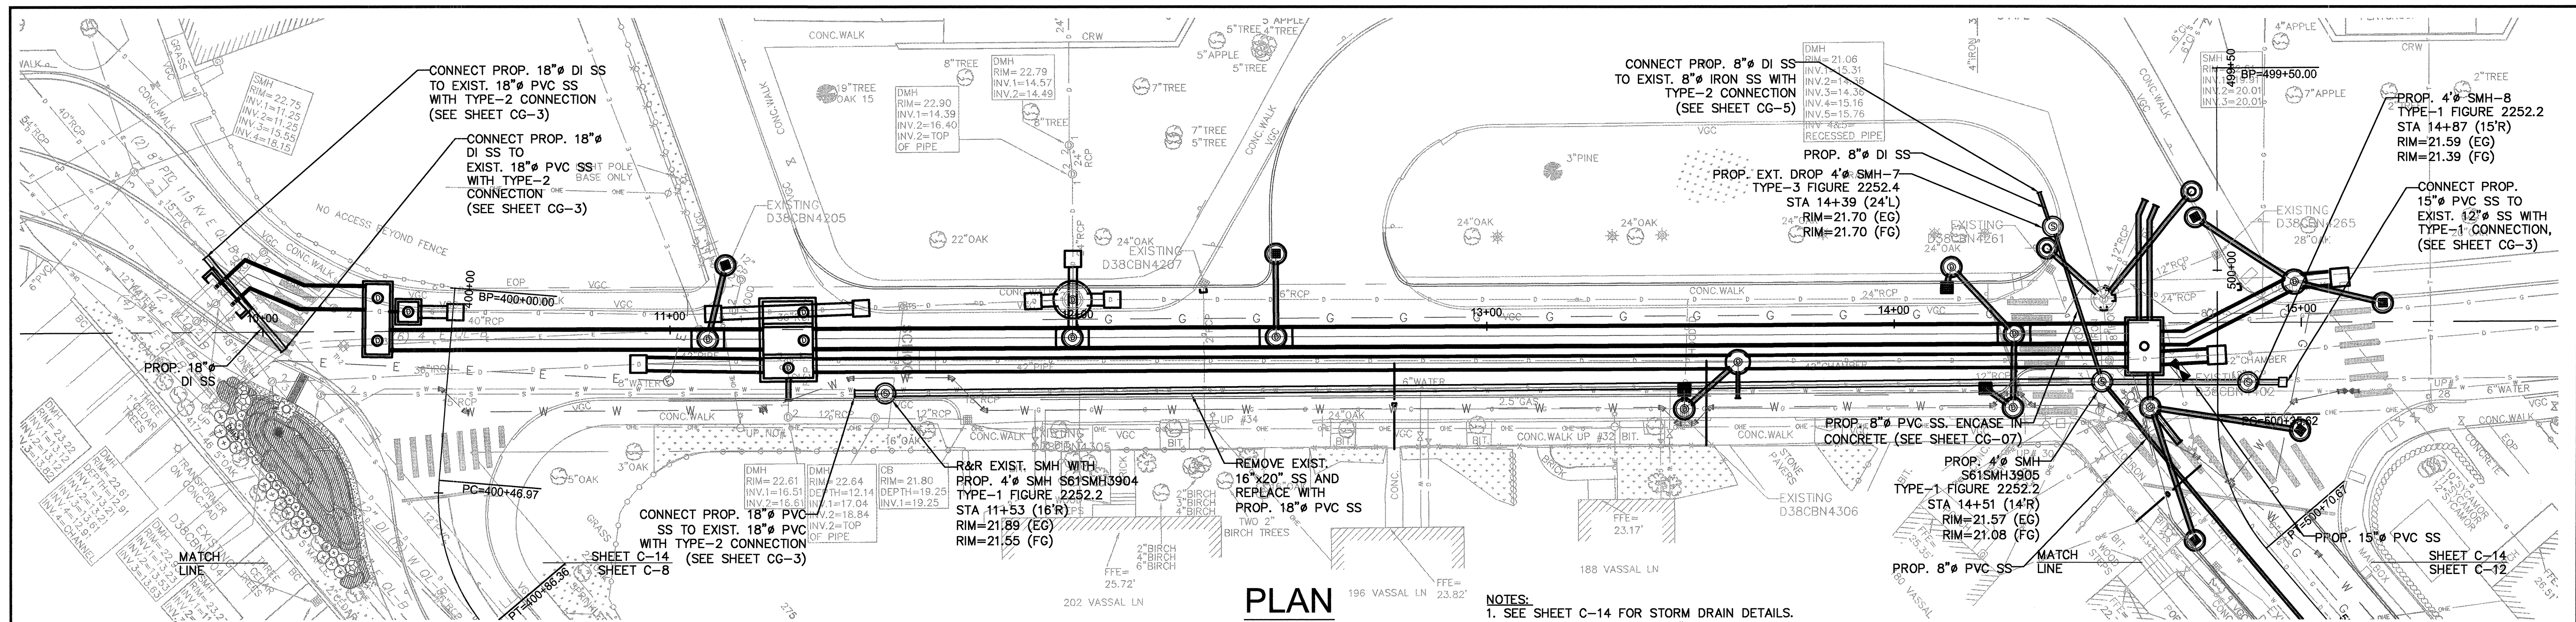


PLAN
1"=20"

- NOTES:**
1. SEE SHEET C-14 FOR STORM DRAIN DETAILS.
 2. ALL PIPES LARGER THAN 8" TO BE ABANDONED SHALL BE PLUGGED AND FILLED WITH CDF.
 3. CDF SHALL BE USED BETWEEN ALL PIPES WITH HORIZONTAL CLEARANCES LESS THAN 2.5'.

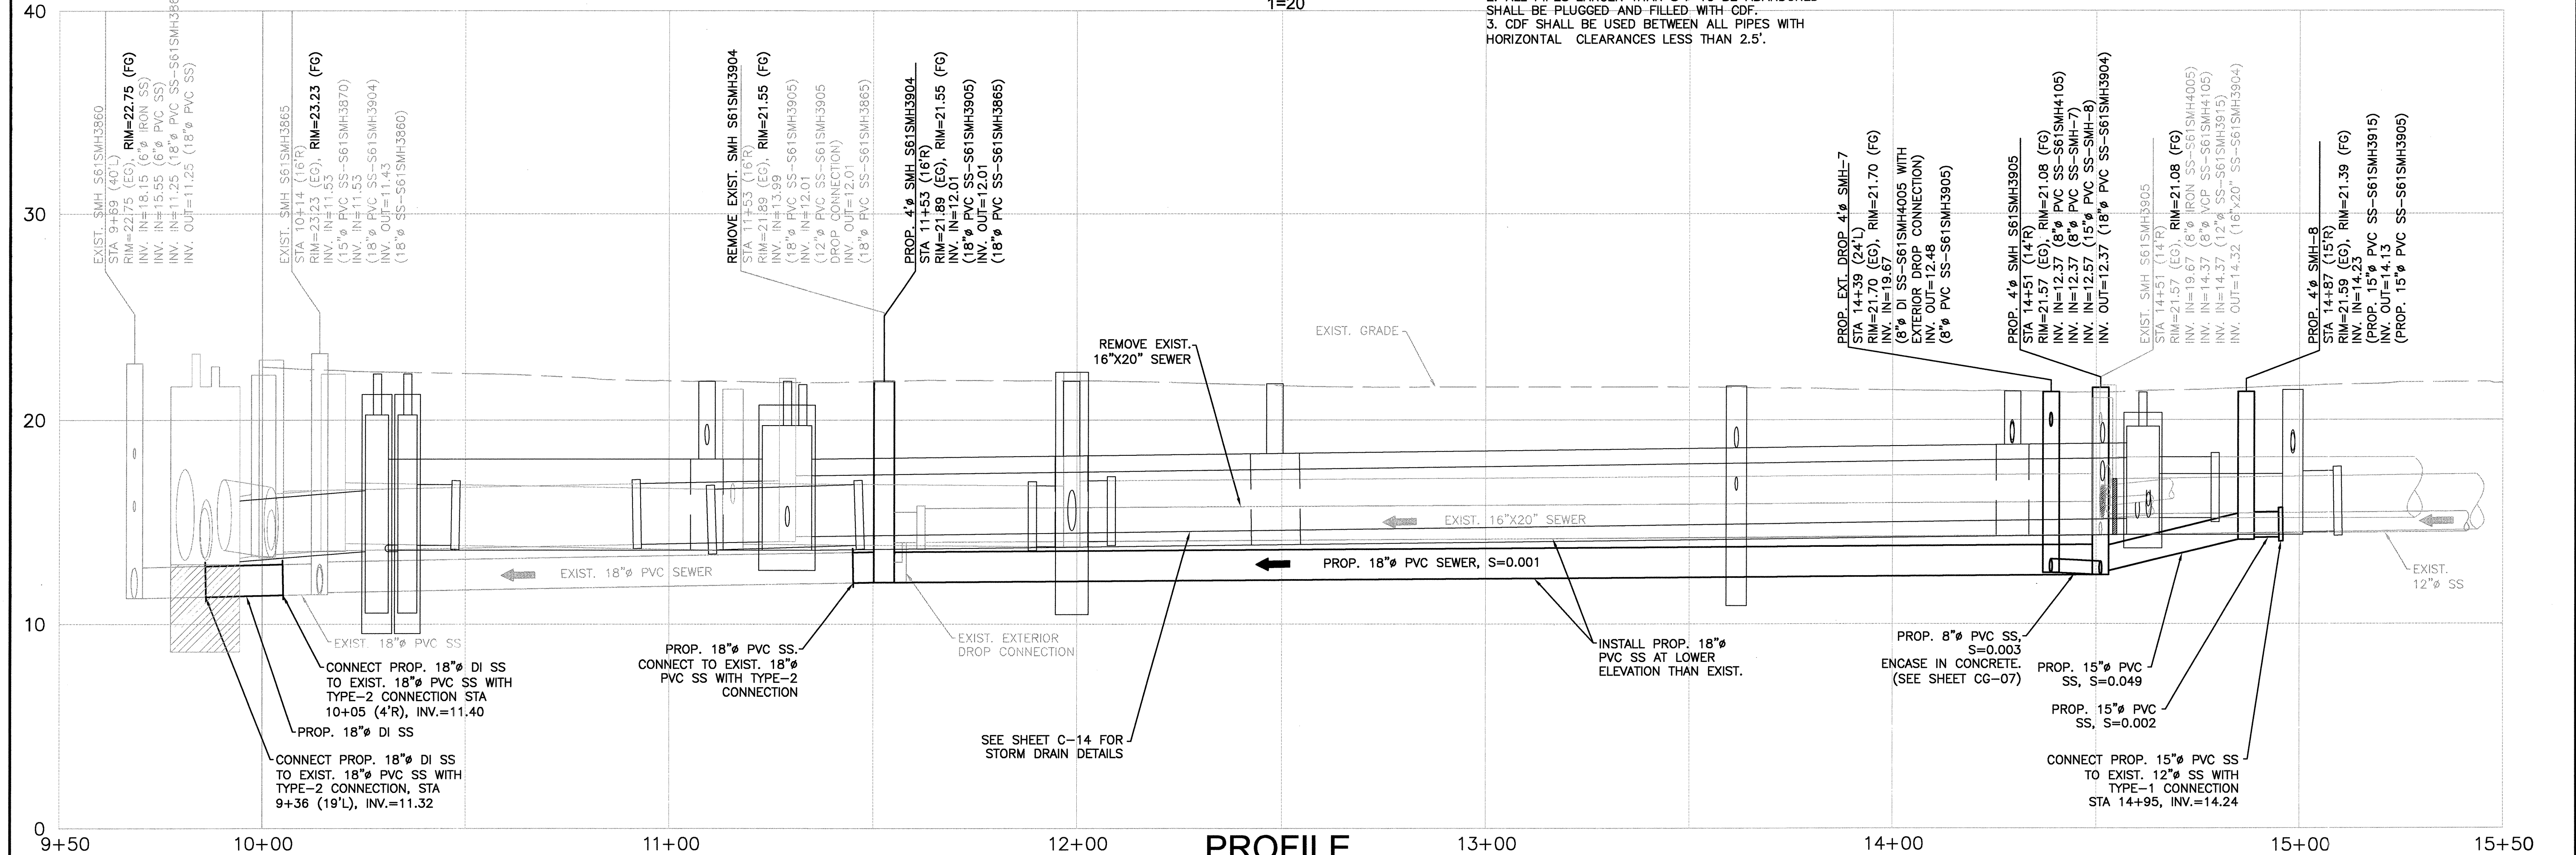


PROFILE
HORIZONTAL SCALE: 1"=20"
VERTICAL SCALE: 1"=4"

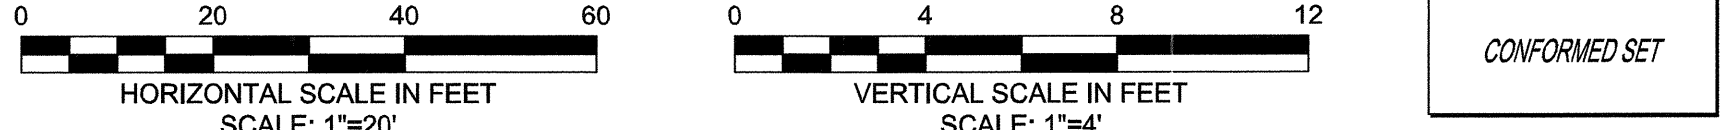


KLEINFELDER SEA
Bright People. Right Solutions.
MANCHESTER, NEW HAMPSHIRE ROCKY HILL, CONNECTICUT
CAMBRIDGE, MASSACHUSETTS

MWH
285 SUMMER STREET, SUITE 200
BOSTON, MASSACHUSETTS 02210
TEL: (617) 314-7100

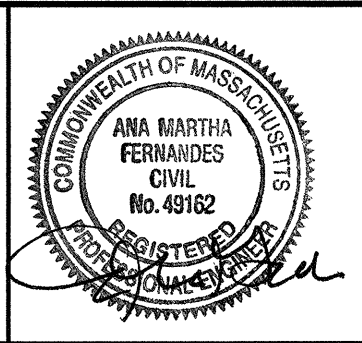


Scale	AS NOTED	Date	SEPTEMBER 2012	Job No.	1010691	Designed by	AMF	Drawn by	ZSH	Checked by	BFR	No.	Description	Date
Approved by	AMF												REVISIONS	

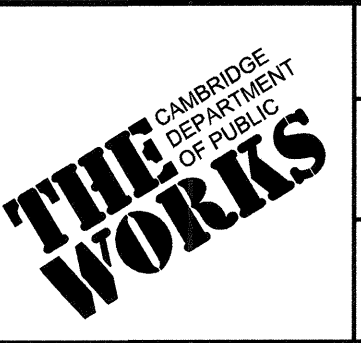


CITY OF CAMBRIDGE, MASSACHUSETTS
HURON A SEWER SEPARATION PROJECT
CONTRACT NO. 8A
CIVIL - PLAN AND PROFILE FOR VASSAL LANE
SANITARY SEWER (PROFILE II) STA 9+50 TO STA 15+50


Sheet No. **C-15**
File No.

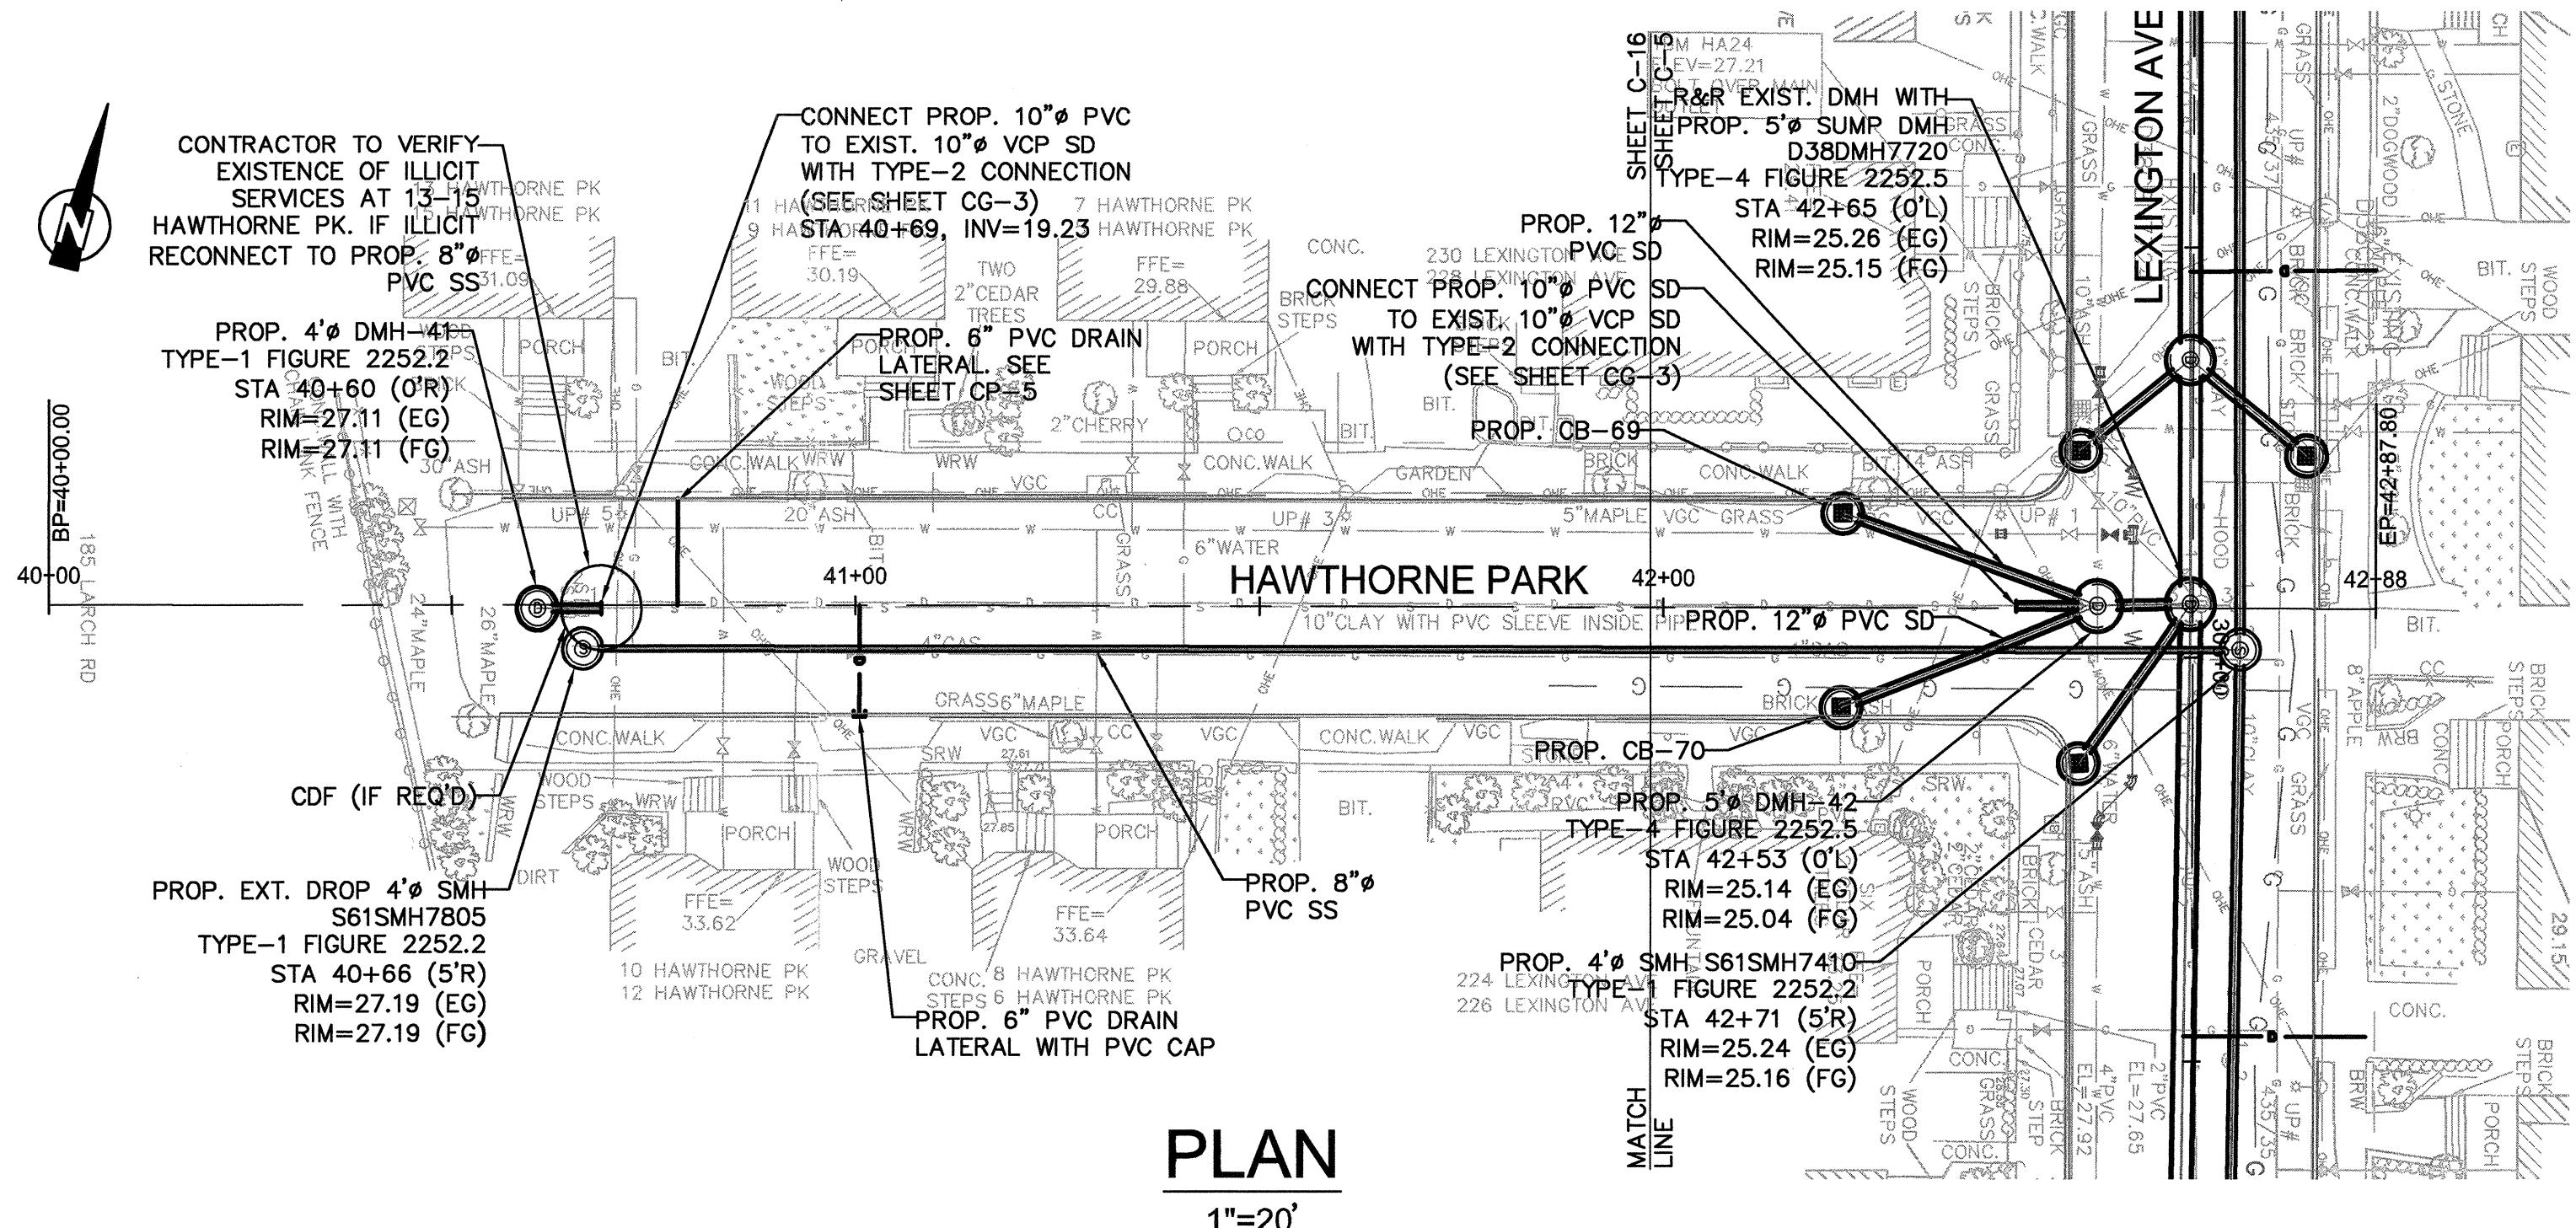


PLAN
1"=20'

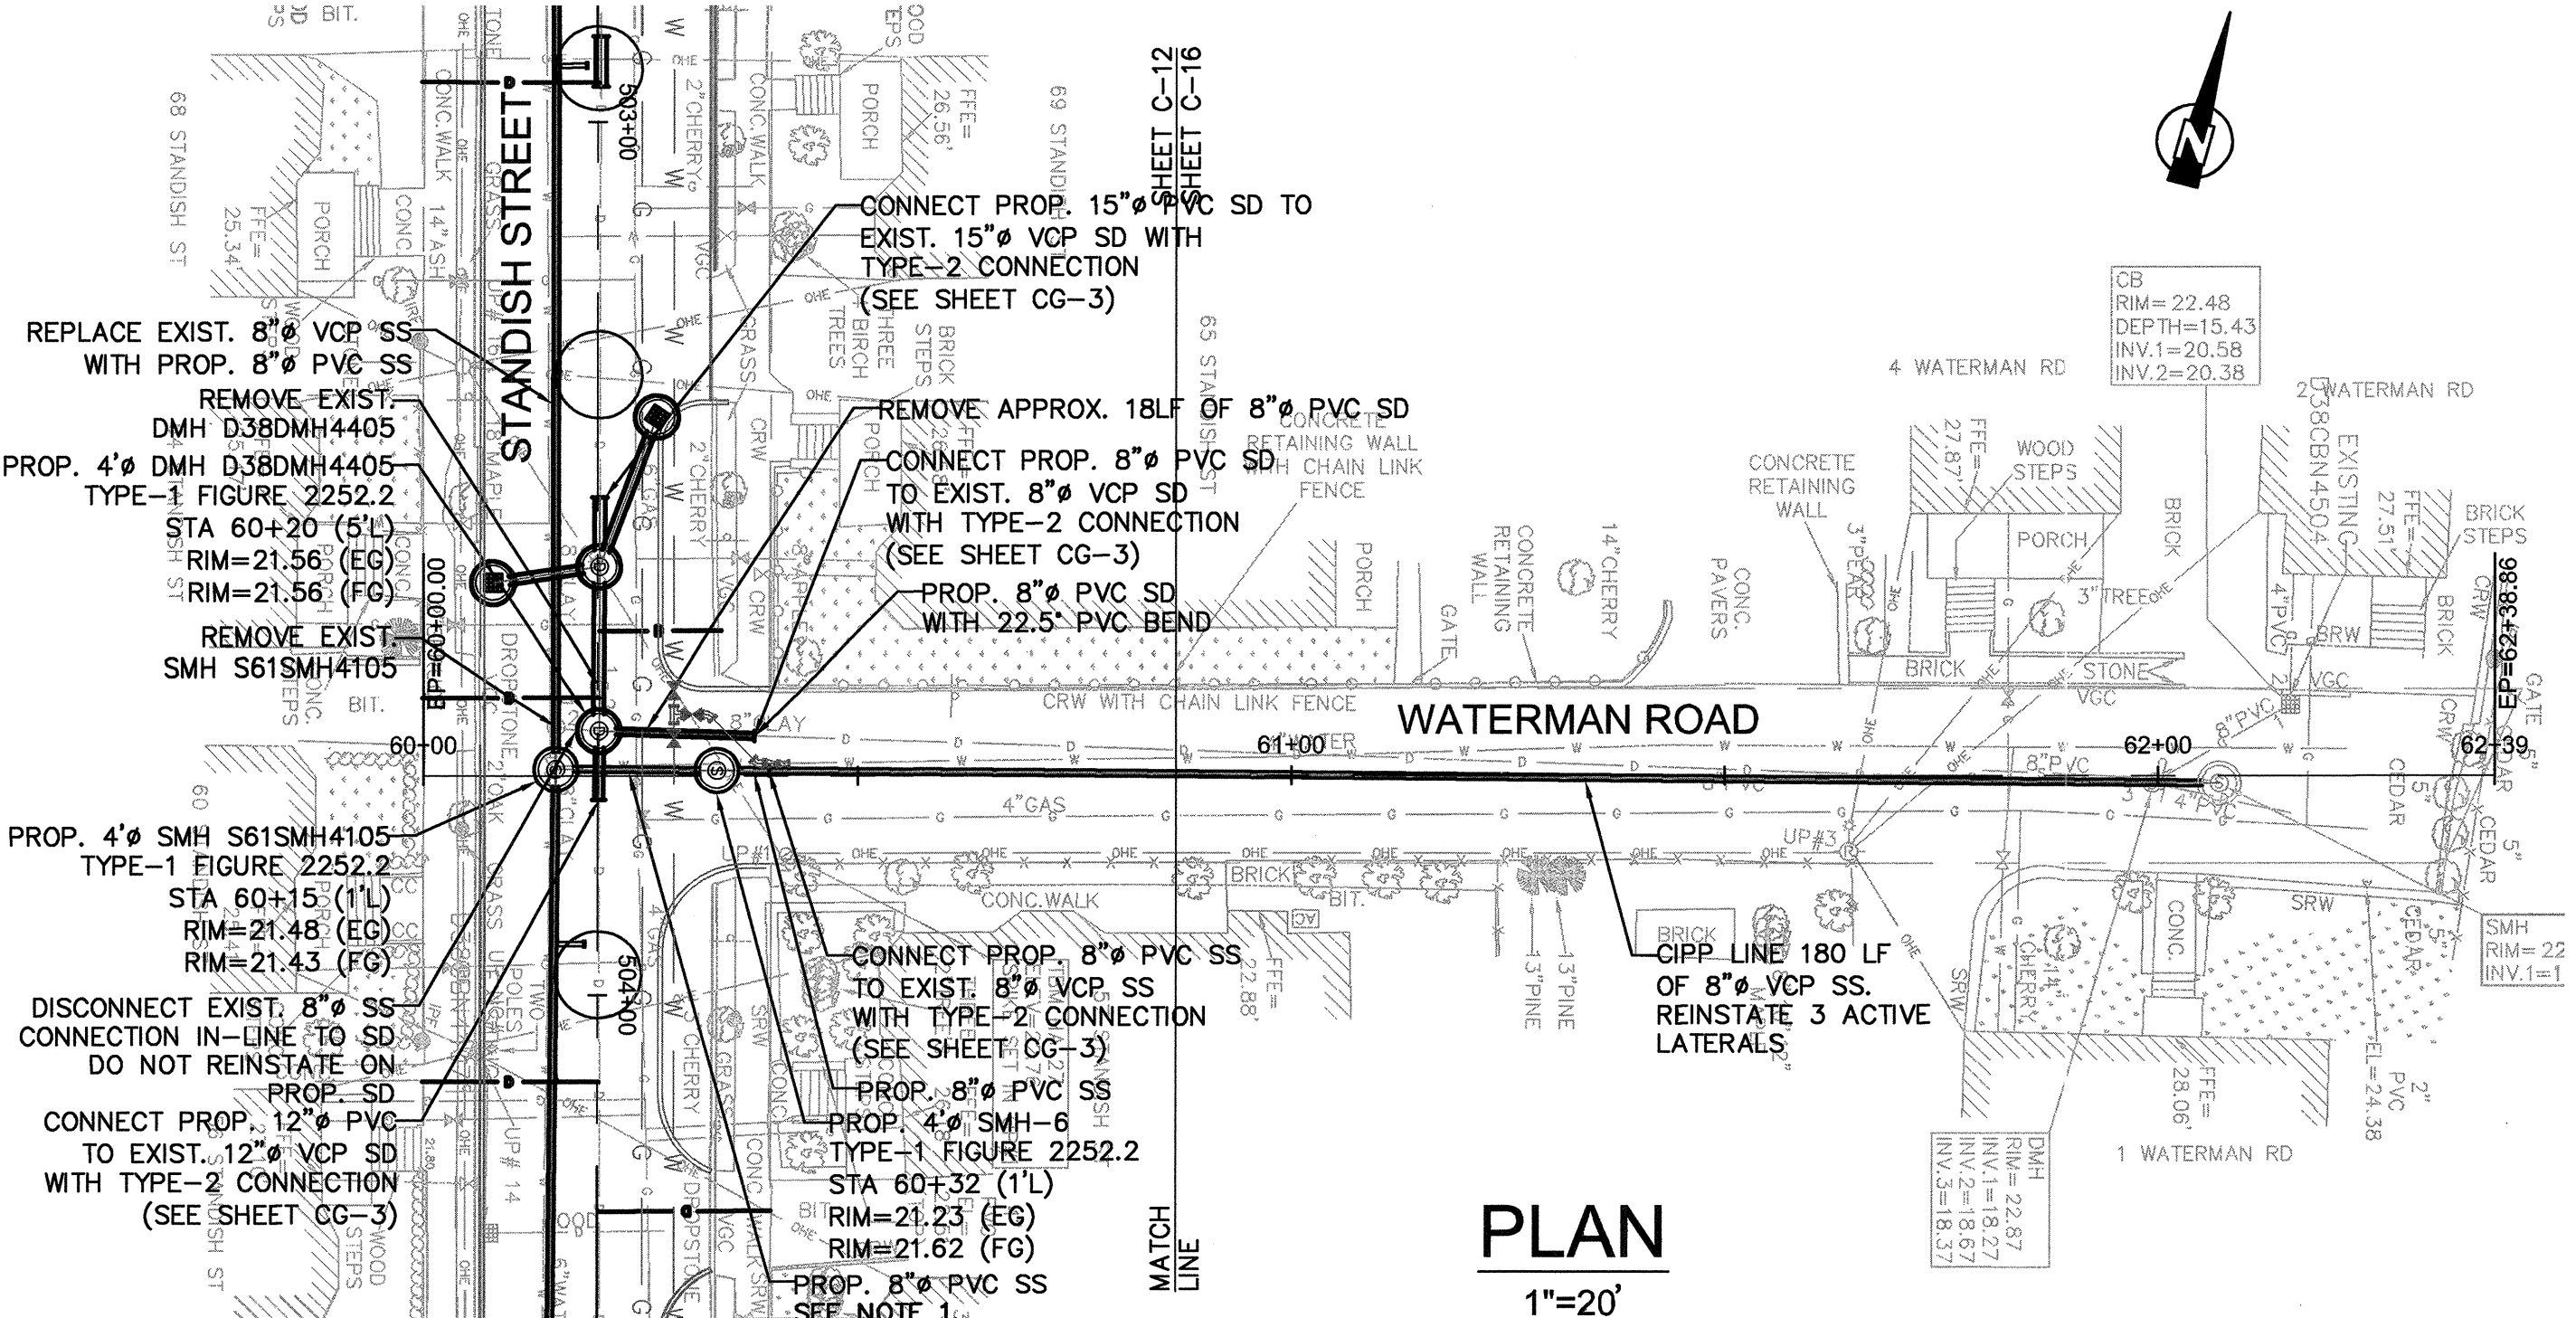

PLAN
1"=20'

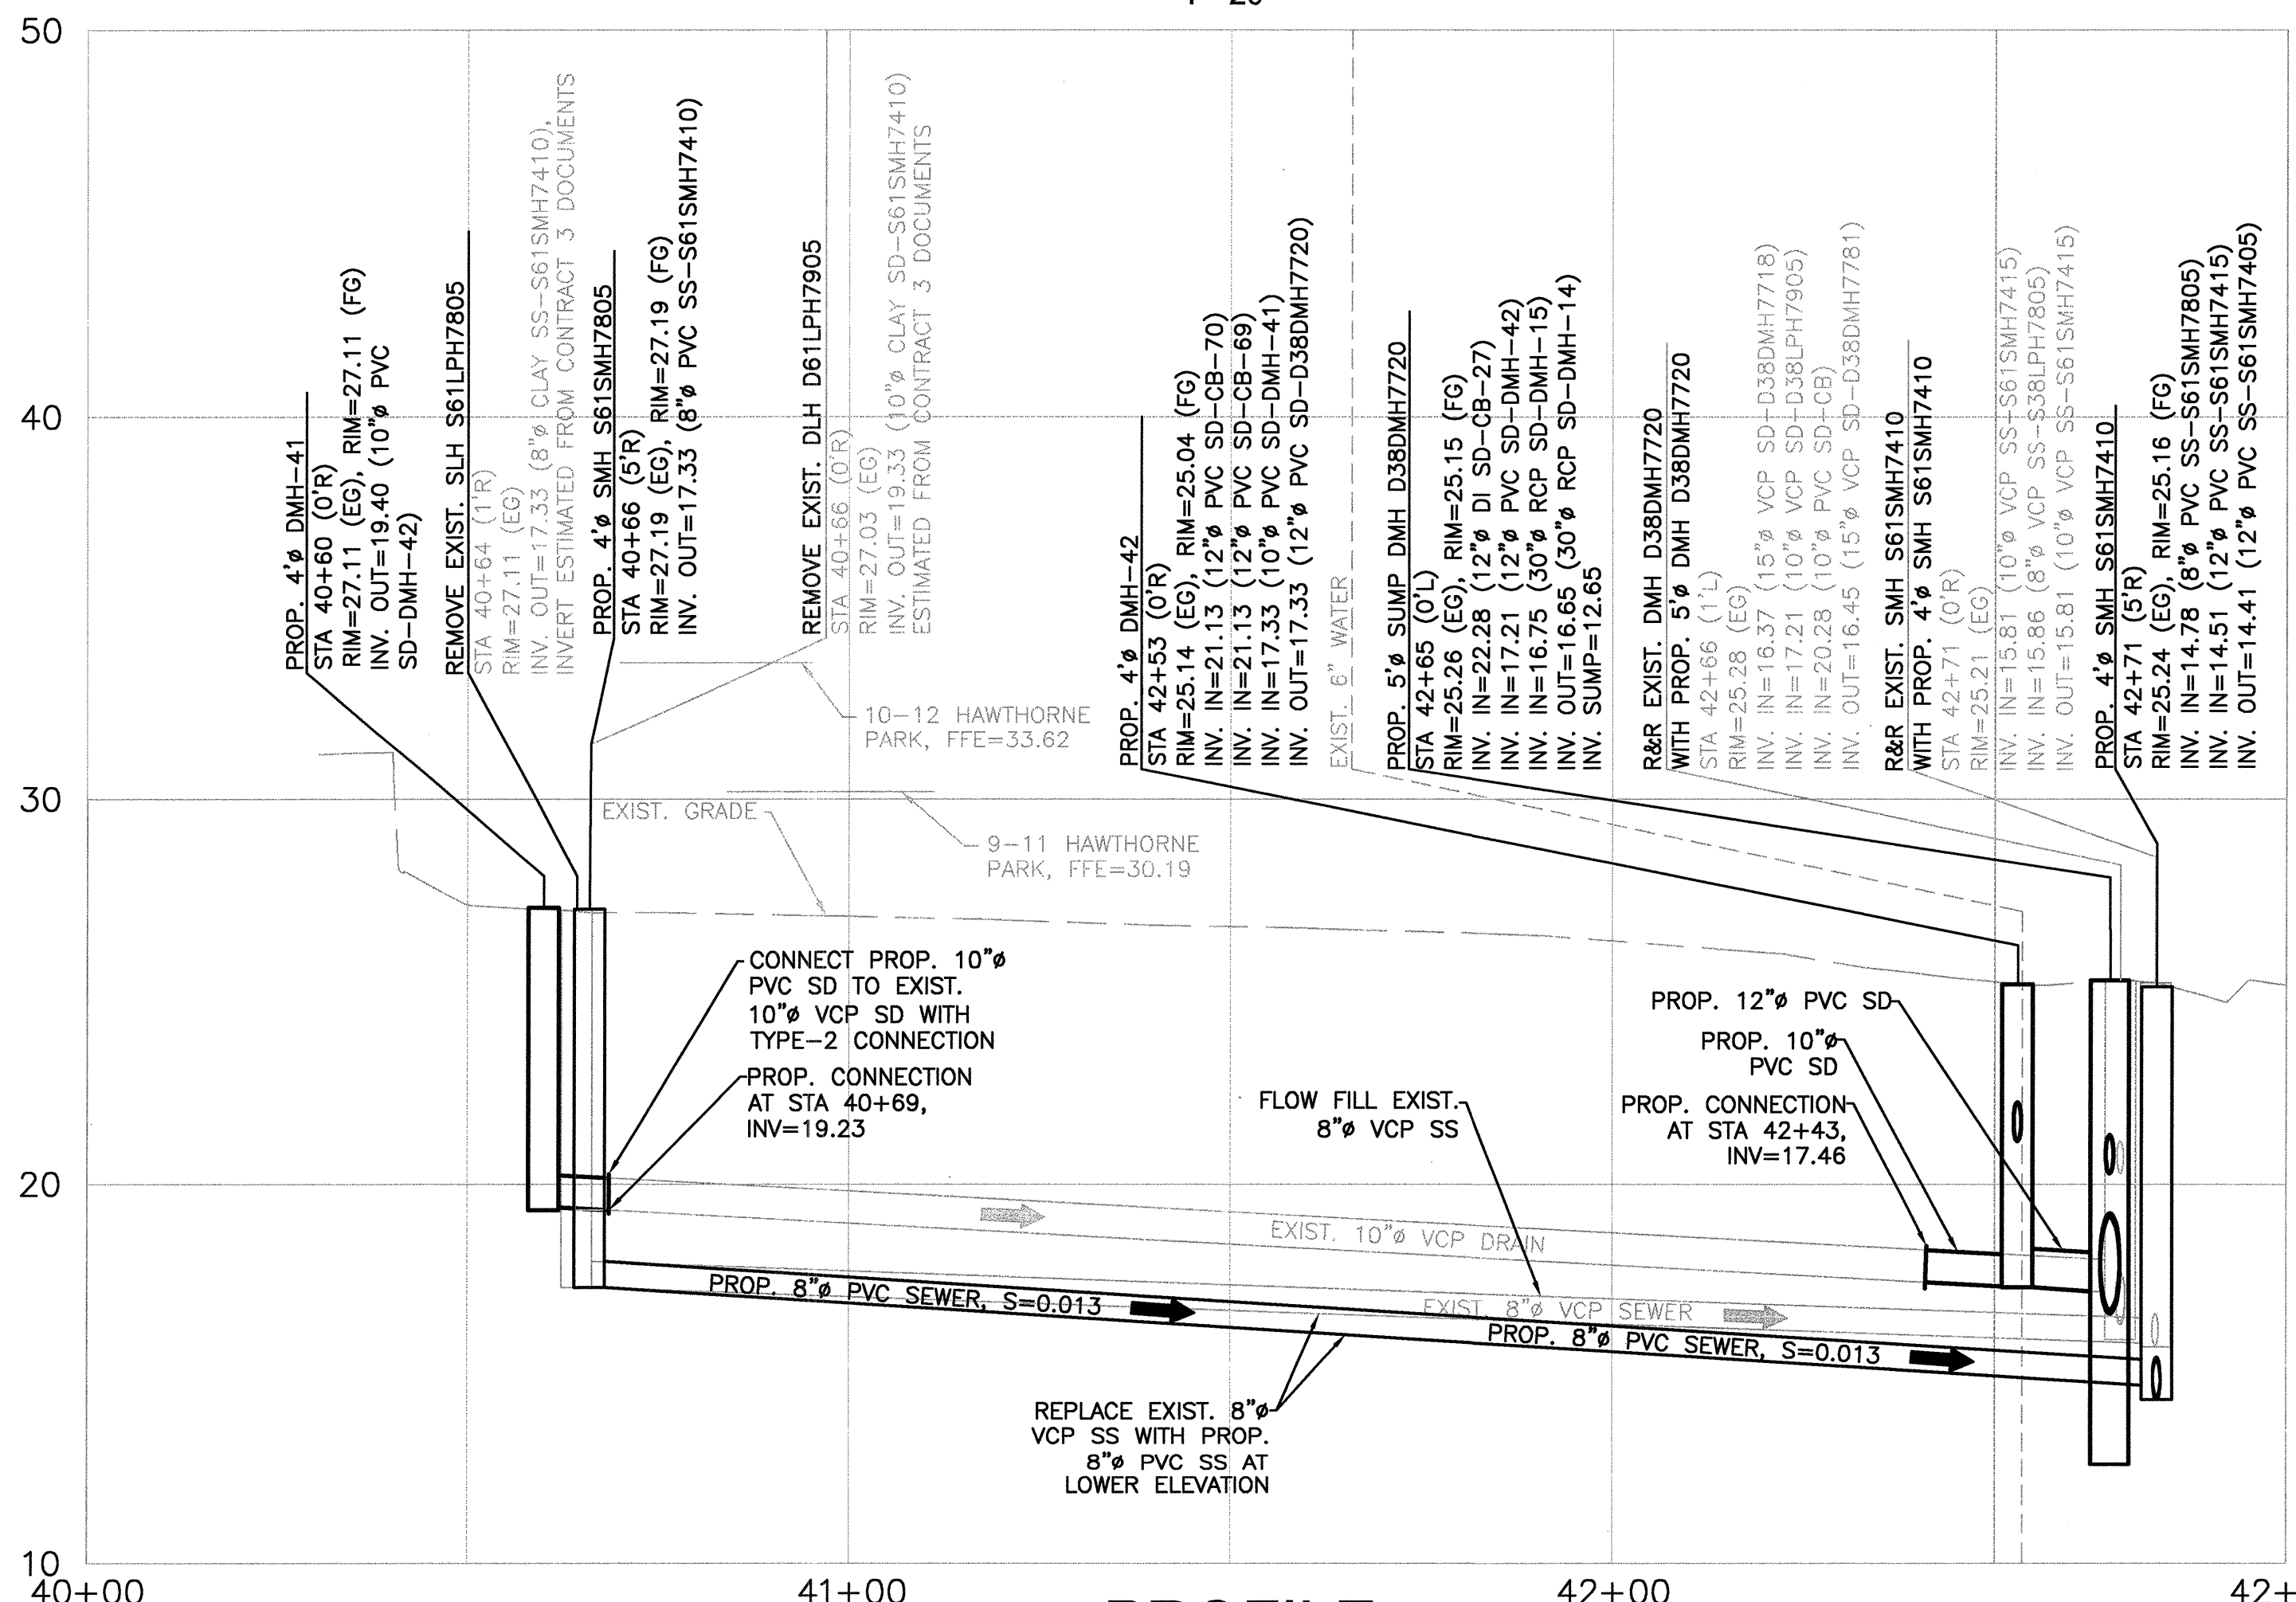


PROFILE
HORIZONTAL SCALE: 1"=20'
VERTICAL SCALE: 1"=4'

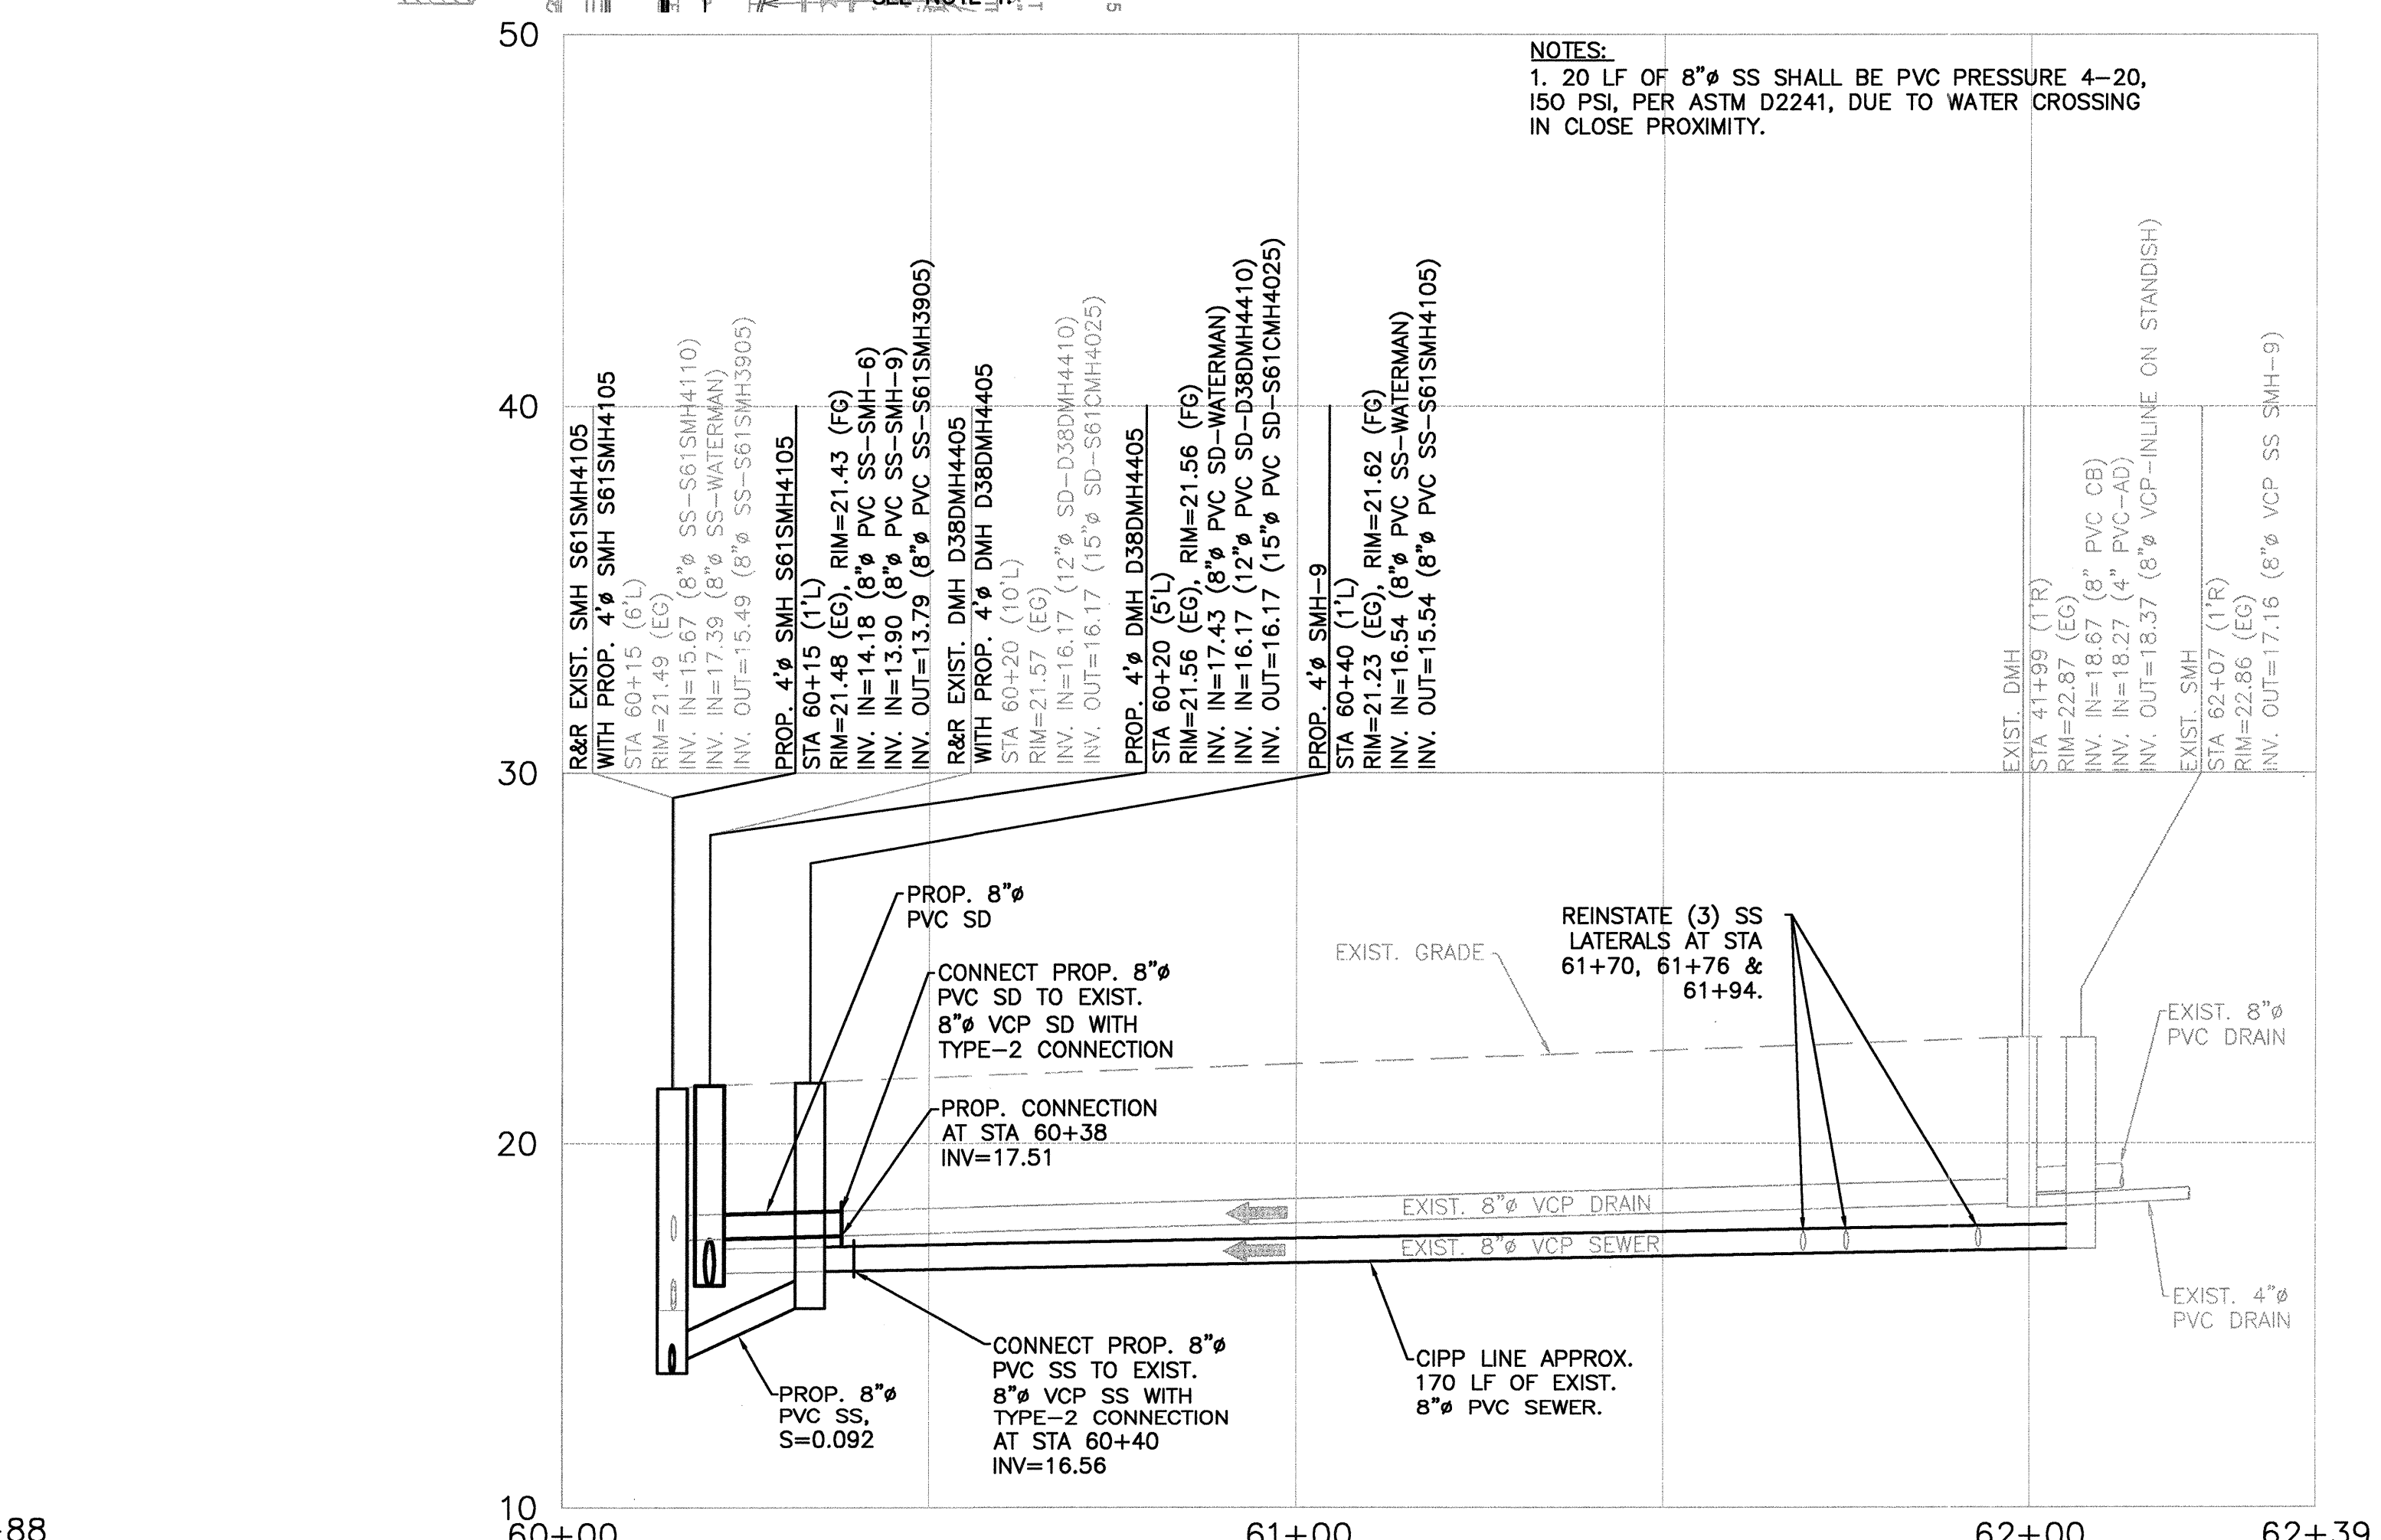

PROFILE
HORIZONTAL SCALE: 1"=20'
VERTICAL SCALE: 1"=4'

CONFORMED SET

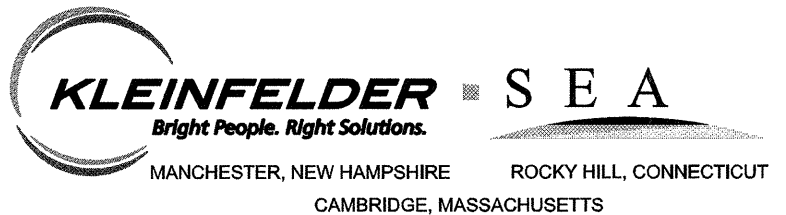


Scale	AS NOTED
Date	SEPTEMBER 2012
Job No.	1010691
Designed by	AMF
Drawn by	ZSH
Checked by	BFR
Approved by	AMF




CITY OF CAMBRIDGE, MASSACHUSETTS
 HURON A SEWER SEPARATION PROJECT
 CONTRACT NO. 8A
 CIVIL - PLAN AND PROFILE HAWTHORNE PARK & WATERMAN ROAD STA 40+00 TO STA 42+88 & STA 60+00 TO STA 62+39


Sheet No. **C-16**
 File No.

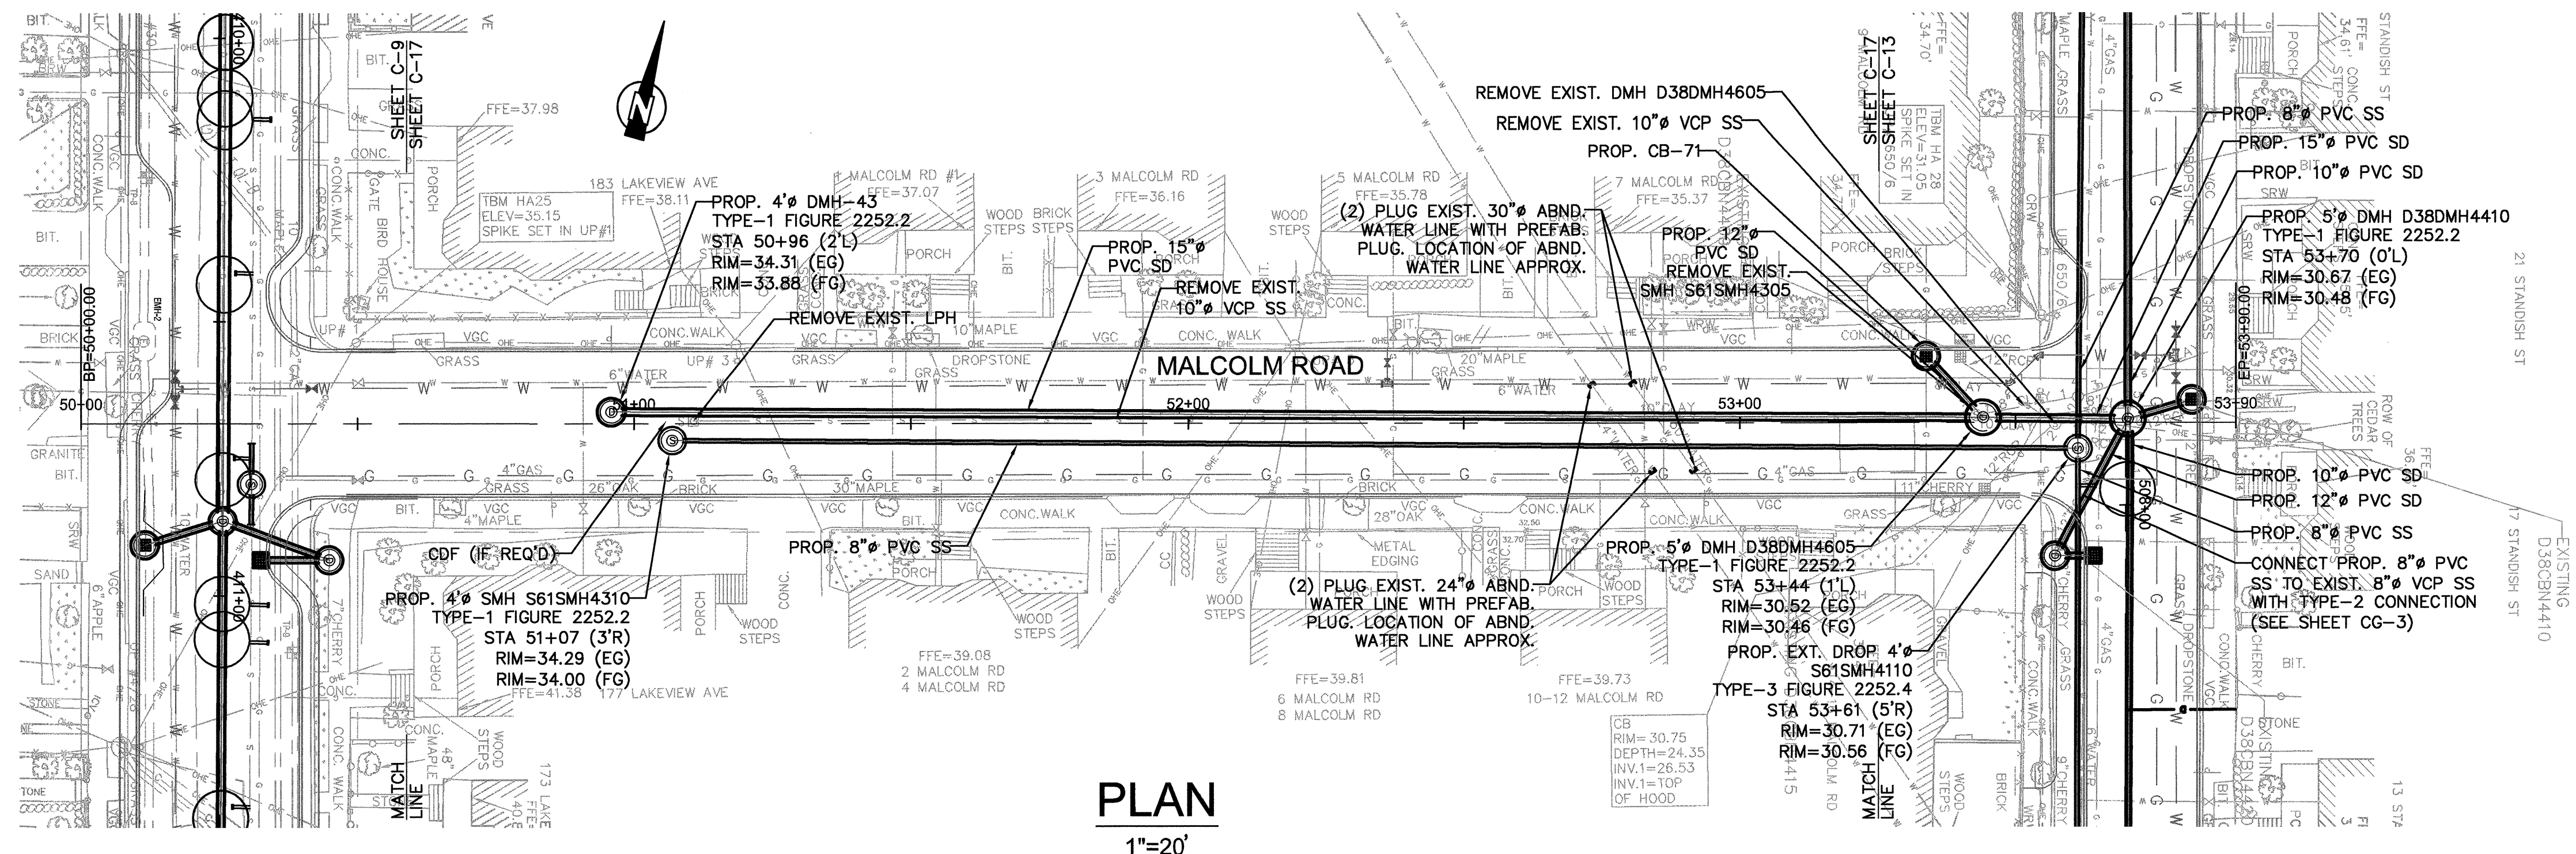


PLAN
1"=20'

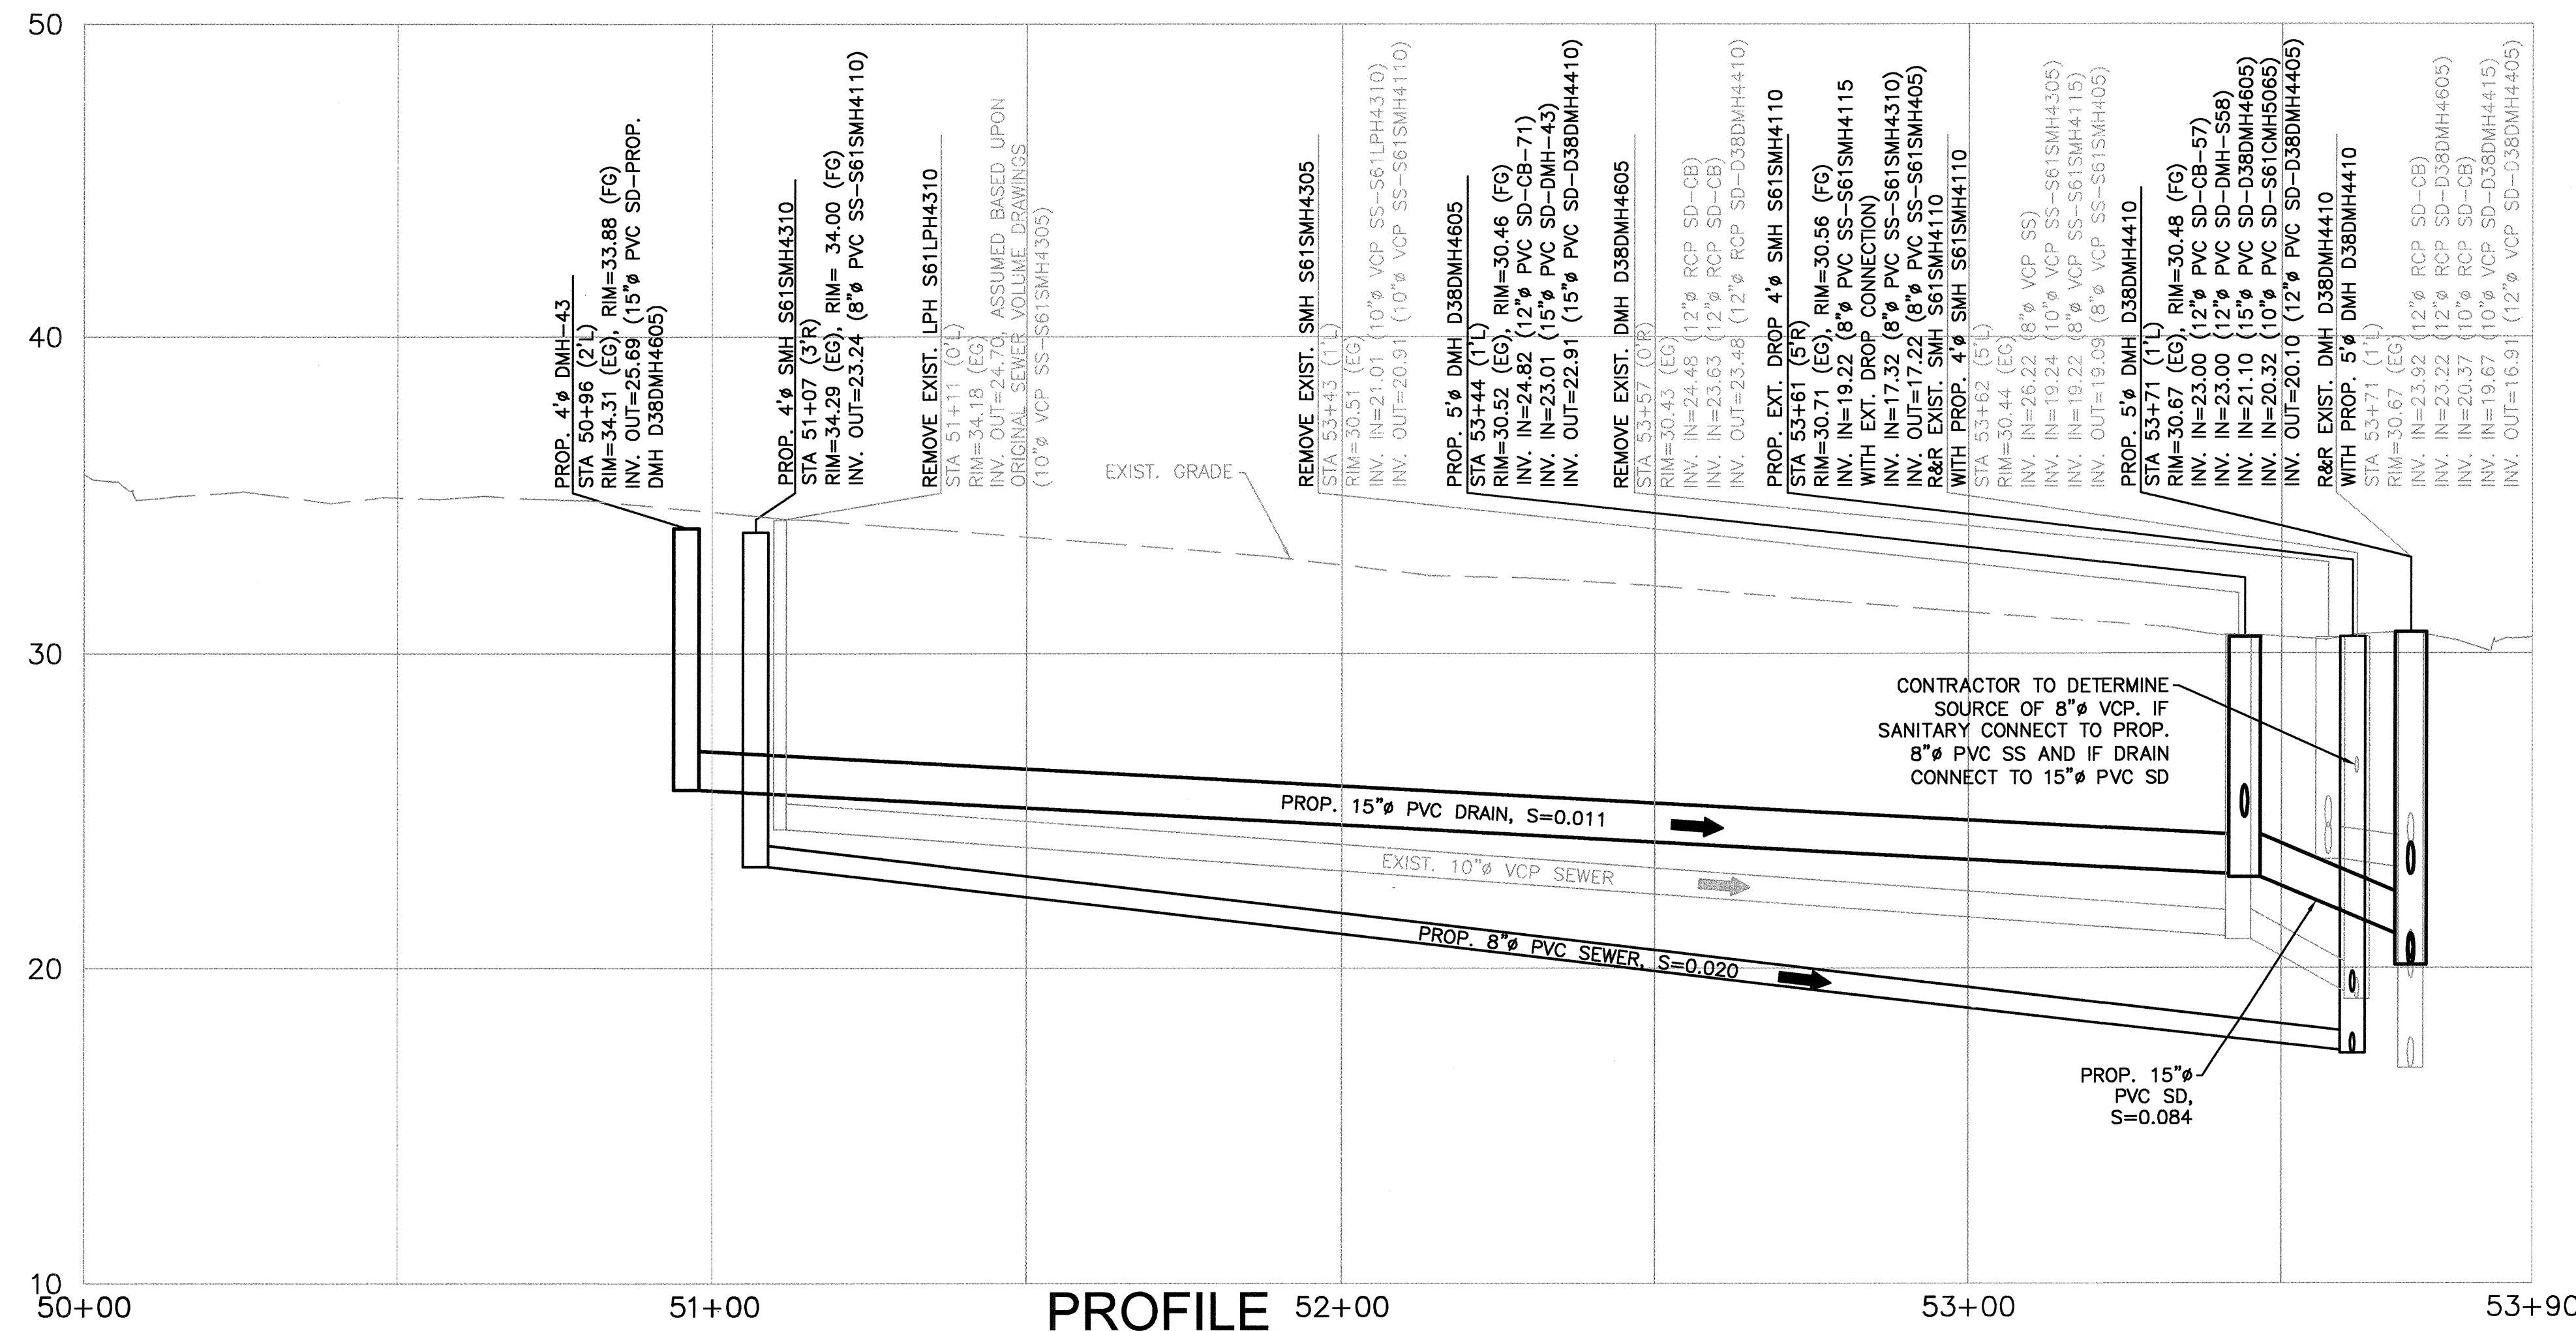

PROFILE
HORIZONTAL SCALE: 1"=20'
VERTICAL SCALE: 1"=4'

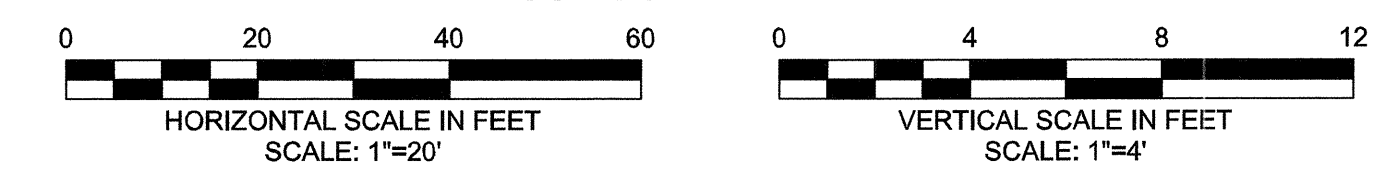

CONFORMED SET


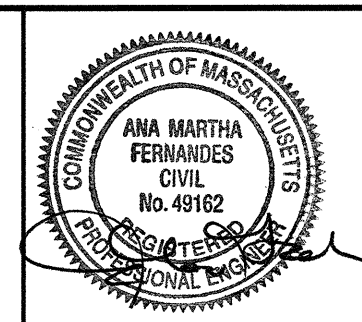


Scale	AS NOTED			
Date	SEPTEMBER 2012			
Job No.	1010691			
Designed by	AMF			
Drawn by	ZSH			
Checked by	BFR	No.	Description	Date
Approved by	AMF		REVISIONS	




CITY OF CAMBRIDGE, MASSACHUSETTS
 HURON A SEWER SEPARATION PROJECT
 CONTRACT NO. 8A
 CIVIL - PLAN AND PROFILE
 MALCOLM ROAD STA 50+00 TO STA 53+90

Sheet No. **C-17**
 File No.

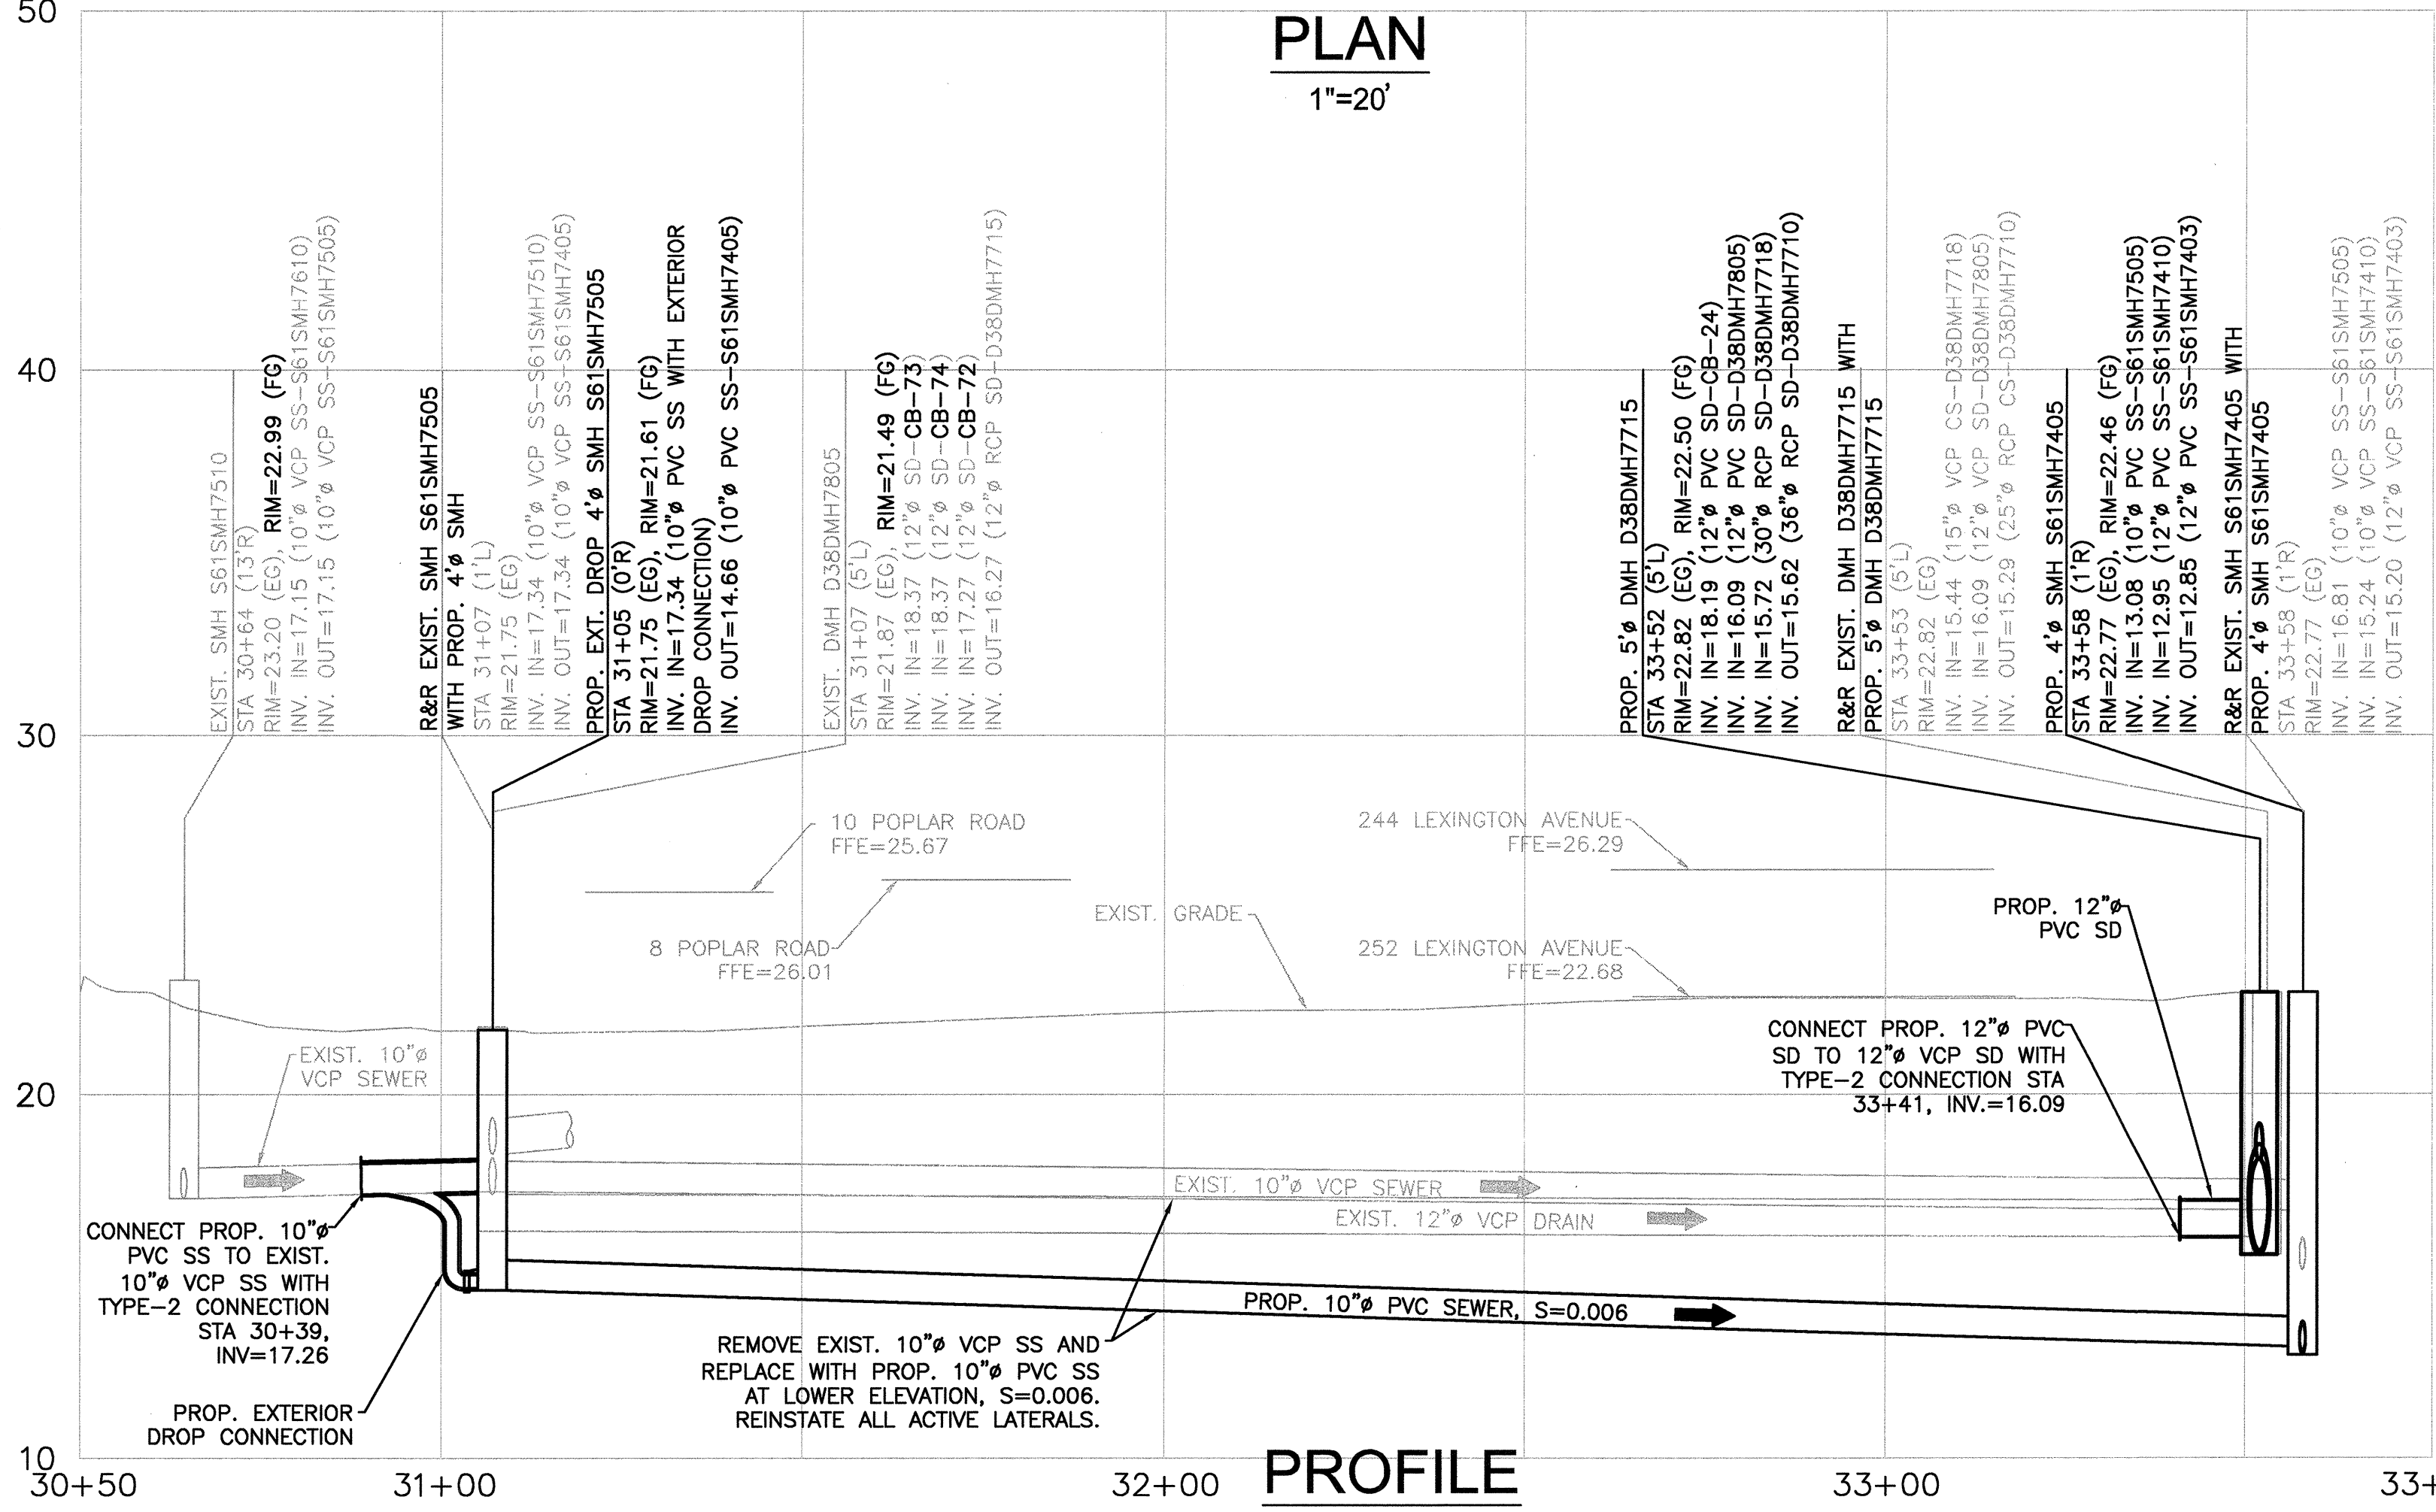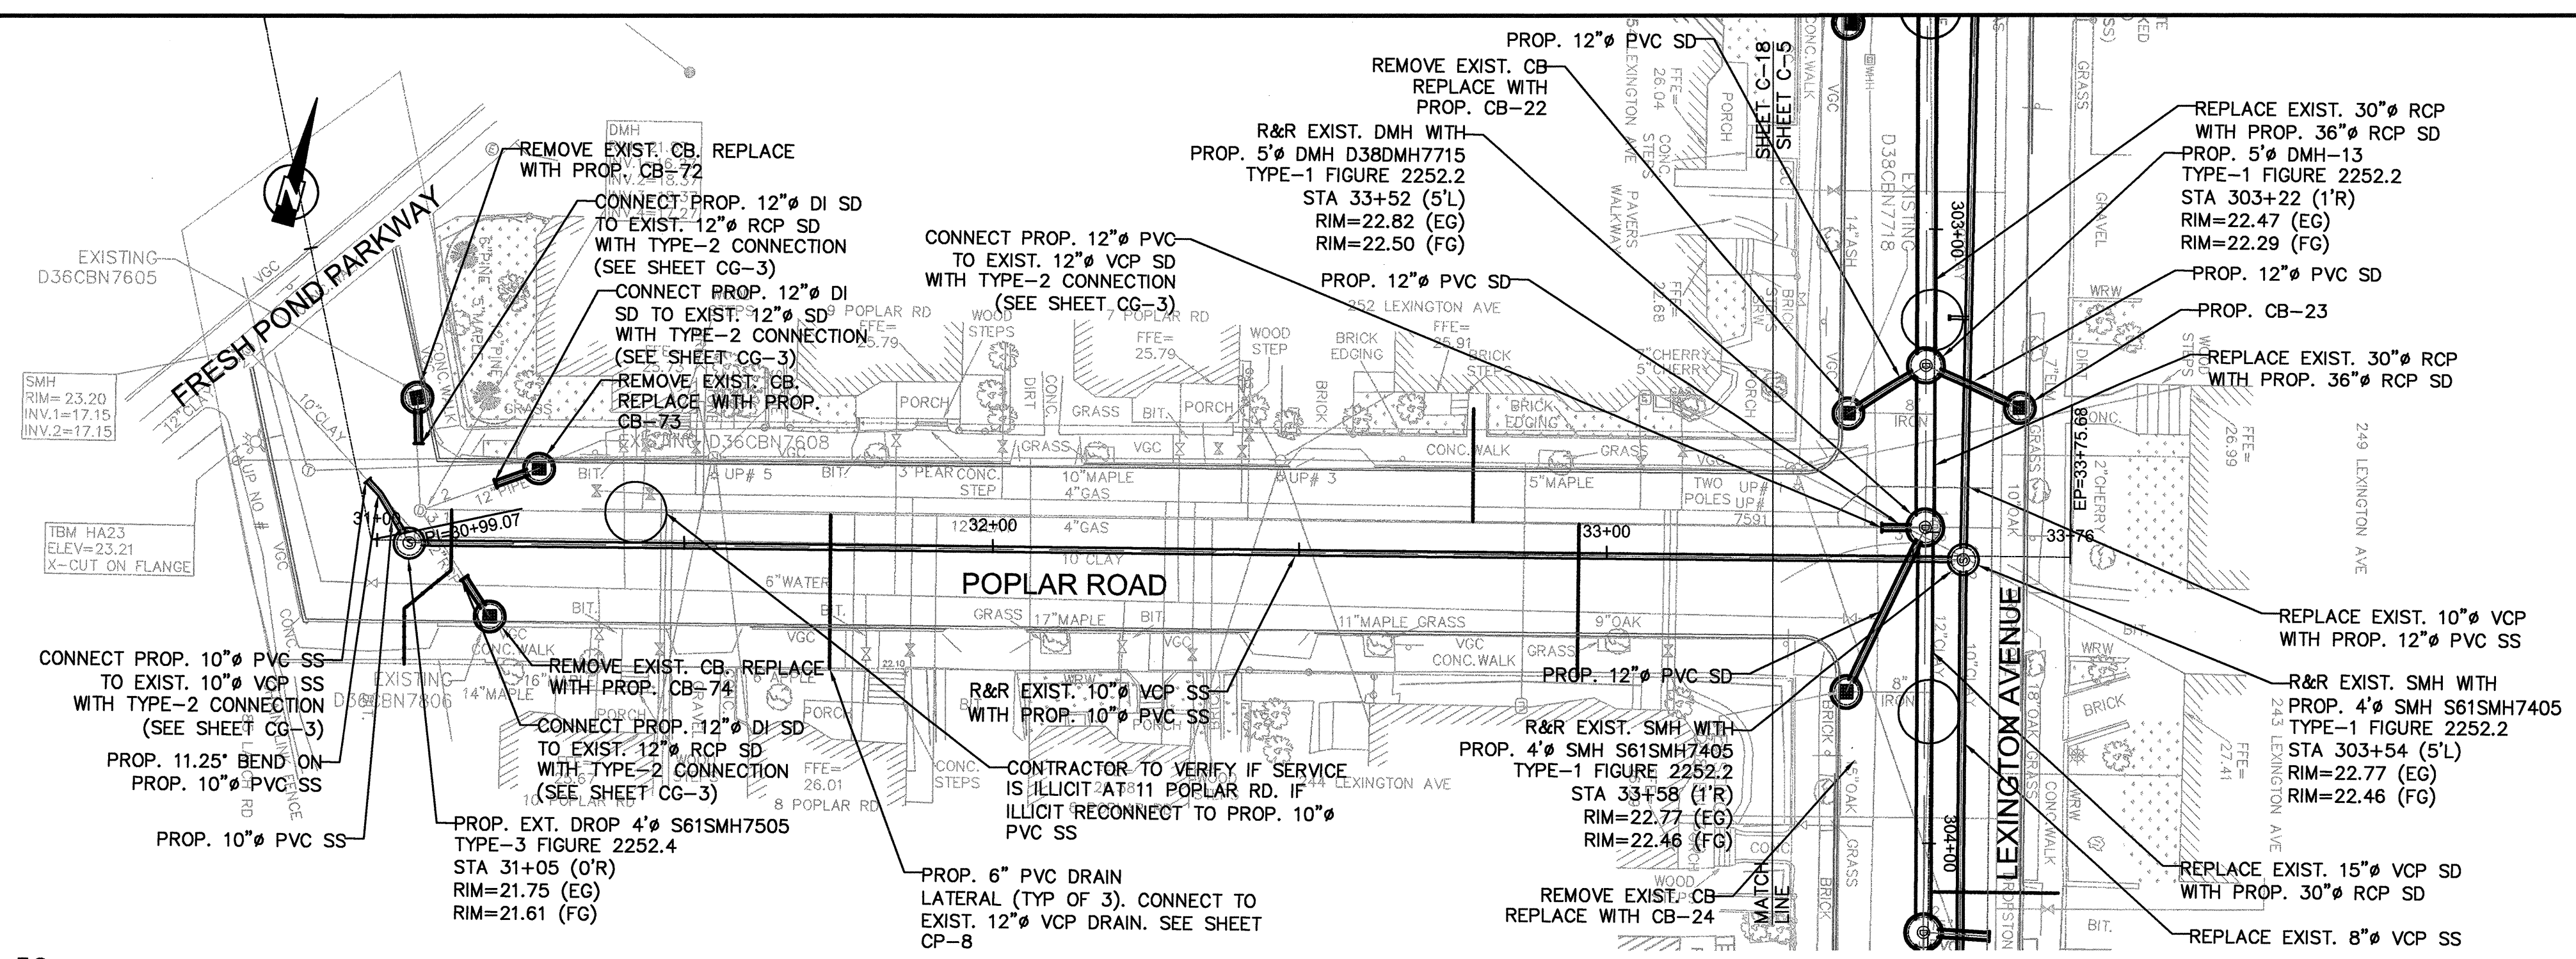

PLAN
1"=20'

PROFILE
HORIZONTAL SCALE: 1"=20'
VERTICAL SCALE: 1"=4'

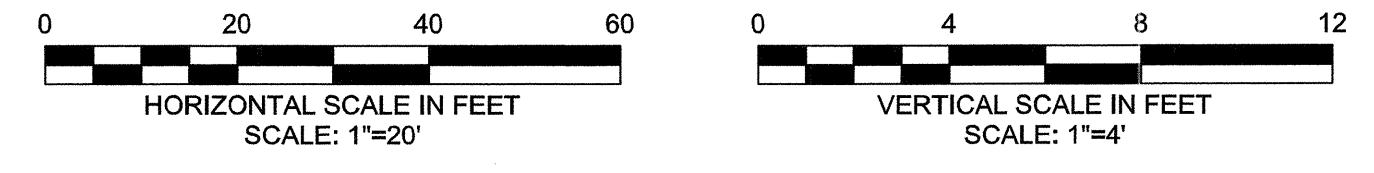

CONFORMED SET



Scale	AS NOTED			
Date	SEPTEMBER 2012			
Job No.	1010691			
Designed by	AMF			
Drawn by	ZSH			
Checked by	BFR	No.	Description	Date
Approved by	AMF		REVISIONS	



CITY OF CAMBRIDGE, MASSACHUSETTS
 HURON A SEWER SEPARATION PROJECT
 CONTRACT NO. 8A
 CIVIL - PLAN AND PROFILE
 POPLAR RD STA 30+50 TO 33+76

Sheet No.
C-18
 File No.