


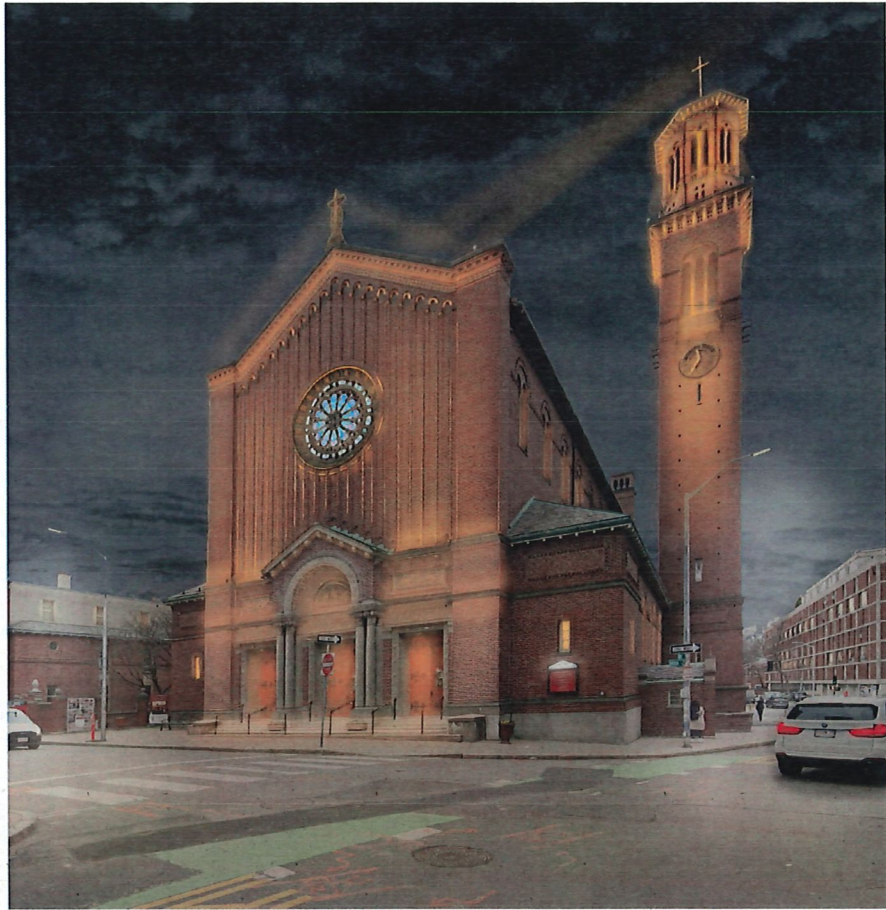

SAINT PAUL'S PARISH
29 MT. AUBURN ST CAMBRIDGE MA 02138
FACADE LIGHTING + CONTROLS UPGRADE
15 MARCH 2025

RIPMAN LIGHTING CONSULTANTS
711 PLEASANT STREET
BELMONT, MA 02478
617-968-5027

INDEX

- R1.01 – Cover Sheet
- R2.01 – R2.14 Lighting Plans, Elevations + Details

LIGHTING CONSULTANT
RIPMAN LIGHTING CONSULTANTS
711 PLEASANT ST.
BELMONT, MA 02478
T: 617-968-5027

ST. PAUL'S PARISH
29 MT. AUBURN STREET CAMBRIDGE MA 02138
FACADE LIGHTING + CONTROLS UPGRADE

R1.01

COVER SHEET

Drawn By: BDR	Checked By: CHR
------------------	--------------------

Date 15MARCH2025

V4

ST. PAUL'S PARISH
29 MT. AUBURN STREET CAMBRIDGE MA 02138
FACADE LIGHTING + CONTROLS UPGRADE

R2.01


ISOMETRIC

Drawn
By: BDR

Checked
By: CHR

Date 15MARCH2025

V4

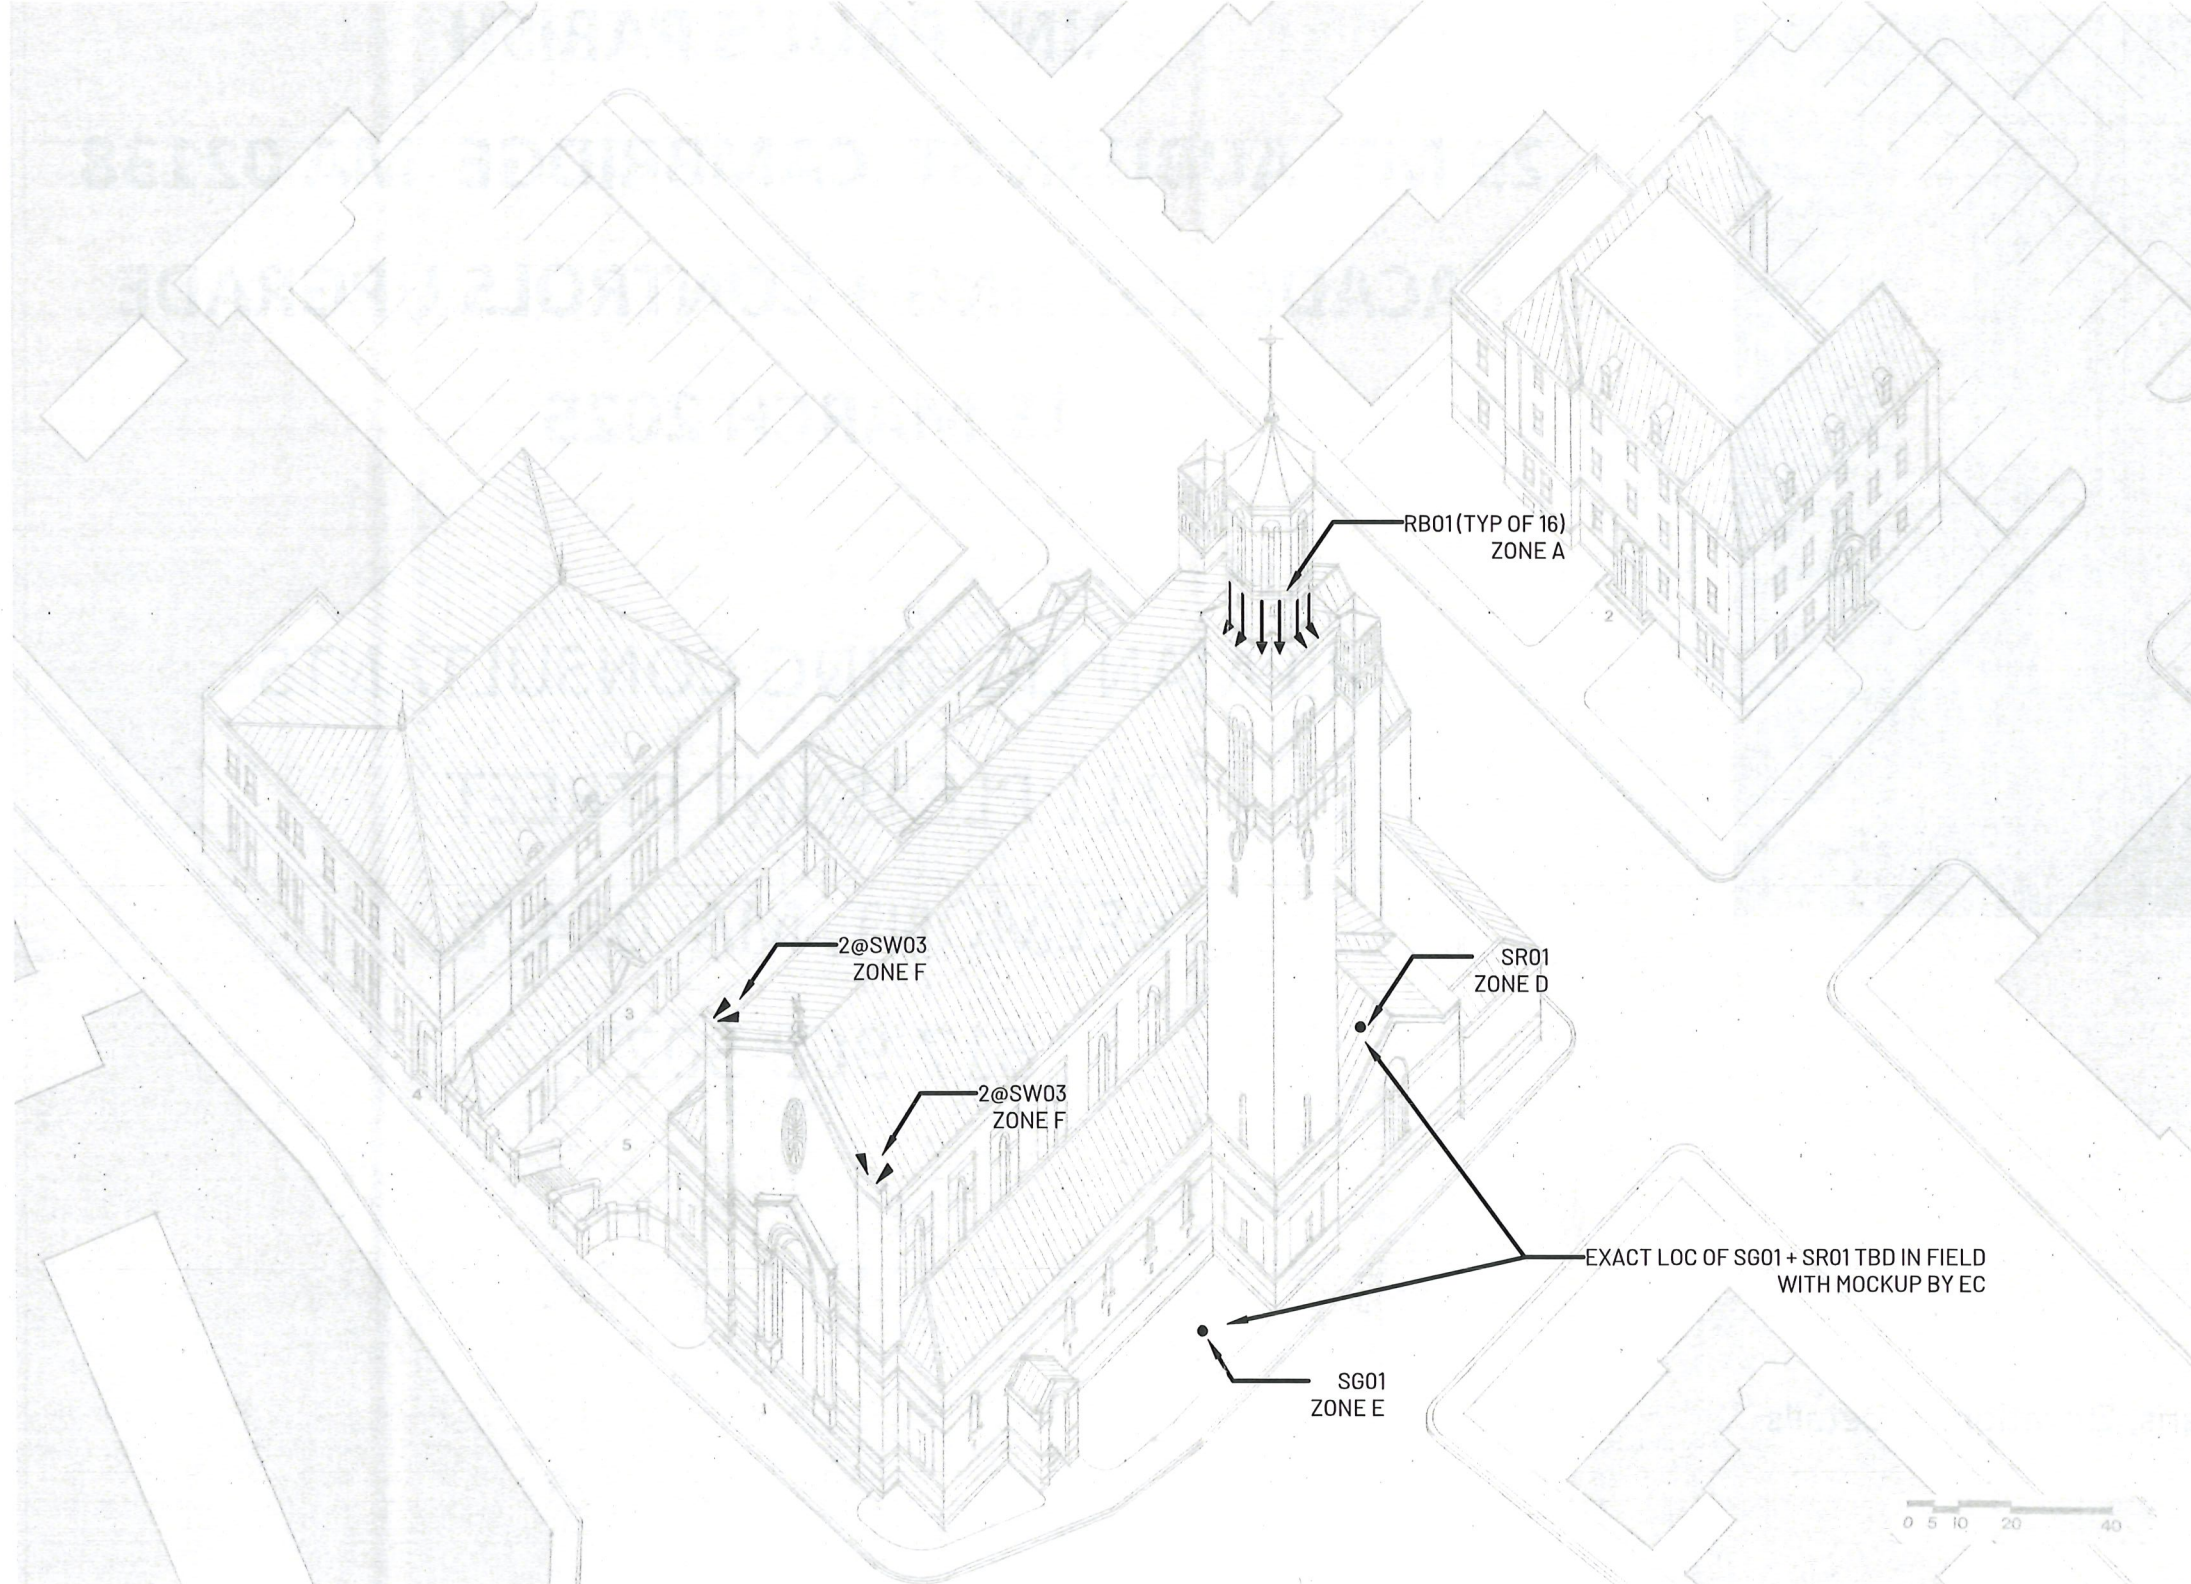

1
R2.01

ISOMETRIC VIEW
SCALE: 1/16"=1'-0"

ST. PAUL'S PARISH
29 MT. AUBURN STREET CAMBRIDGE MA 02138
FACADE LIGHTING + CONTROLS UPGRADE

R2.02


SITE PLAN

Drawn
By: BDR

Checked
By: CHR

Date 15MARCH2025


V4

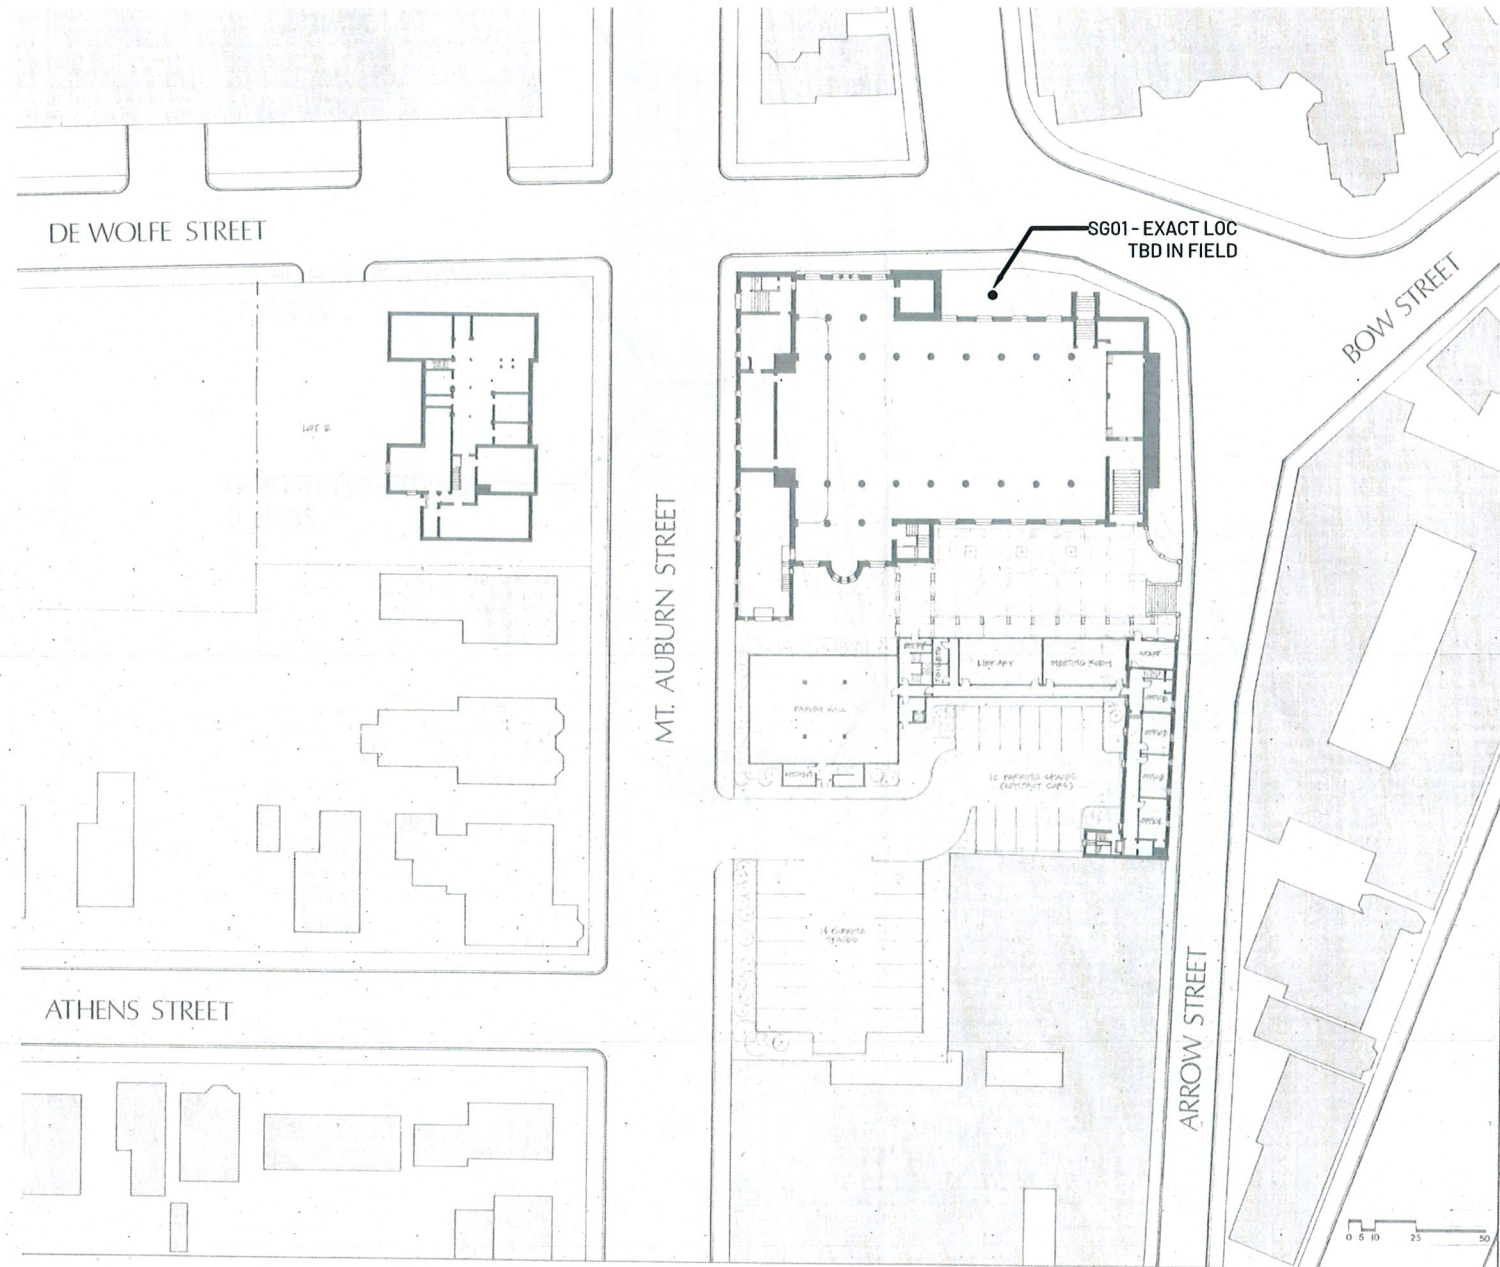

1
R2.02

SITE PLAN
SCALE: 1/32"=1'-0"

ST. PAUL'S PARISH
29 MT. AUBURN STREET CAMBRIDGE MA 02138
FACADE LIGHTING + CONTROLS UPGRADE

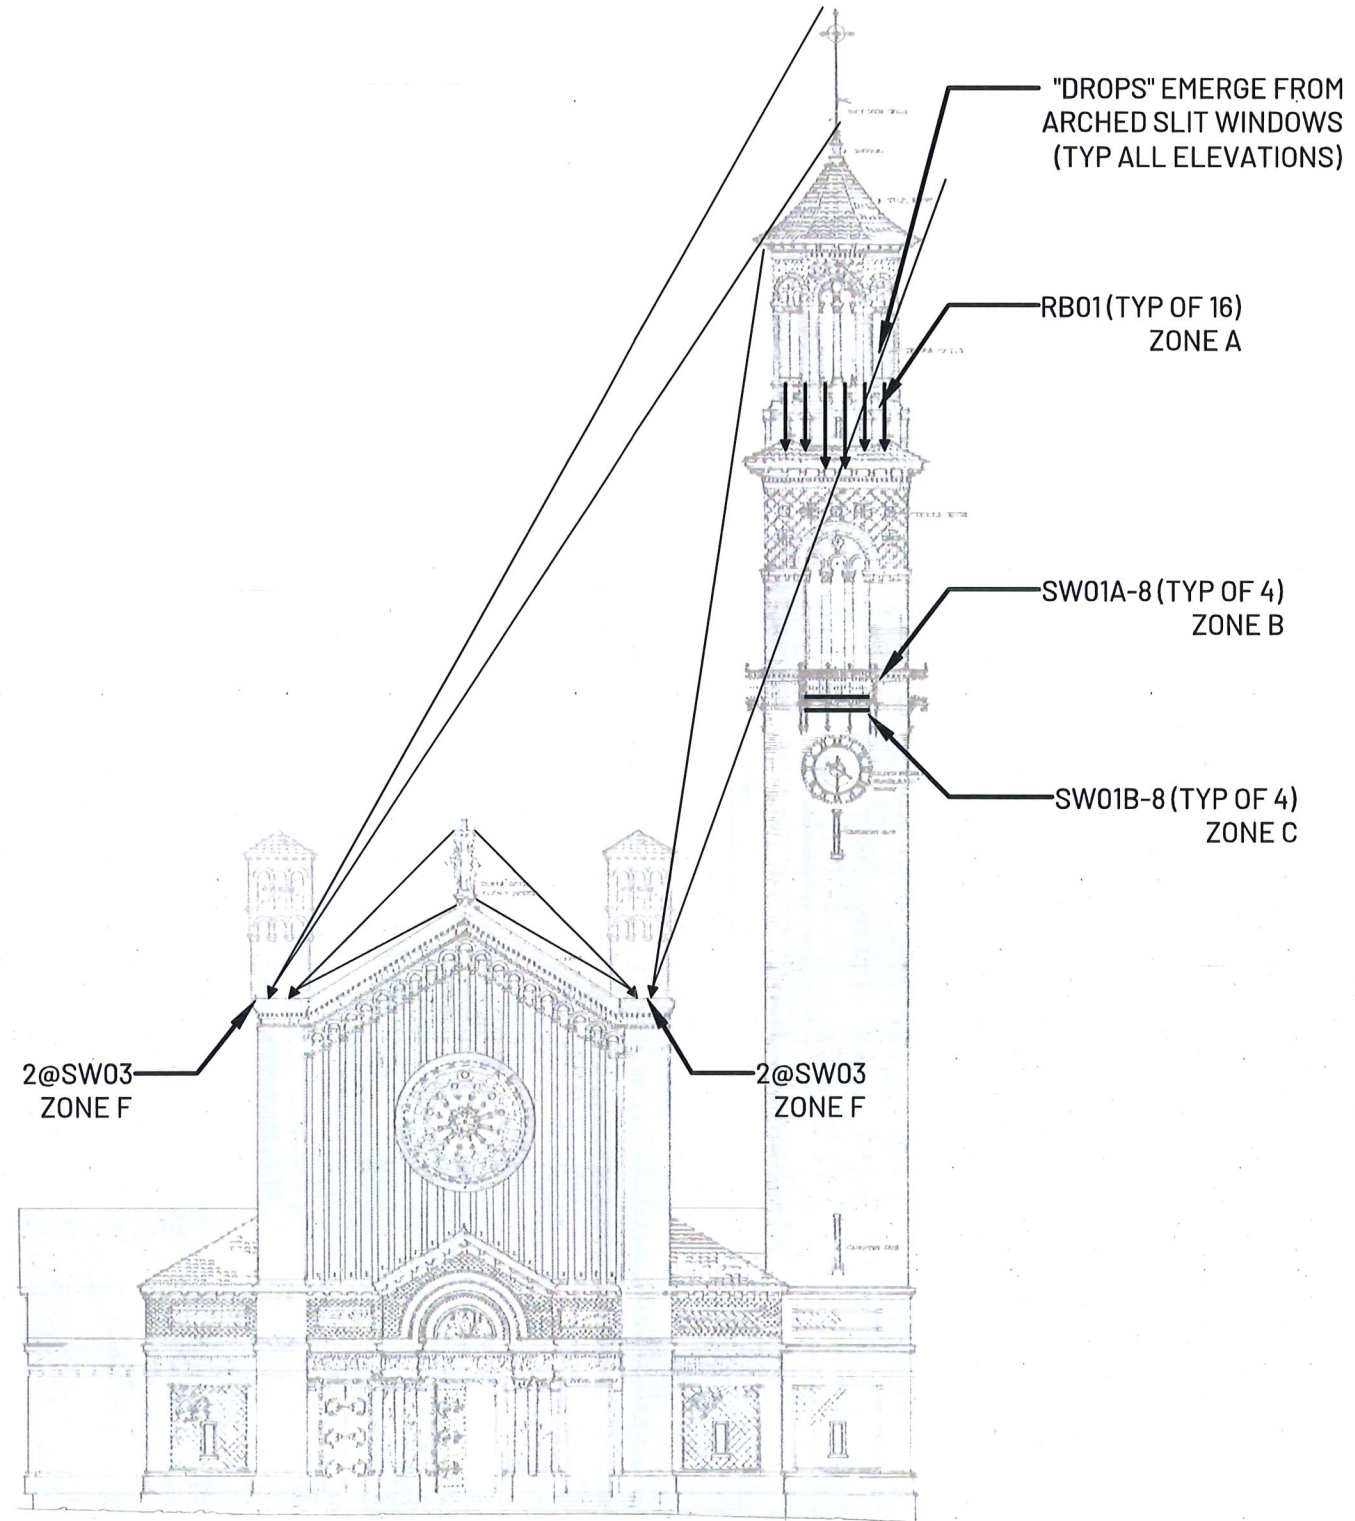

1
R2.03

NORTH ELEVATION
SCALE: 3/32"=1'-0"

R2.03

NORTH ELEVATION


Drawn
By: BDR

Checked
By: CHR

Date 15MARCH2025

V4

ST. PAUL'S PARISH
29 MT. AUBURN STREET CAMBRIDGE MA 02138
FACADE LIGHTING + CONTROLS UPGRADE

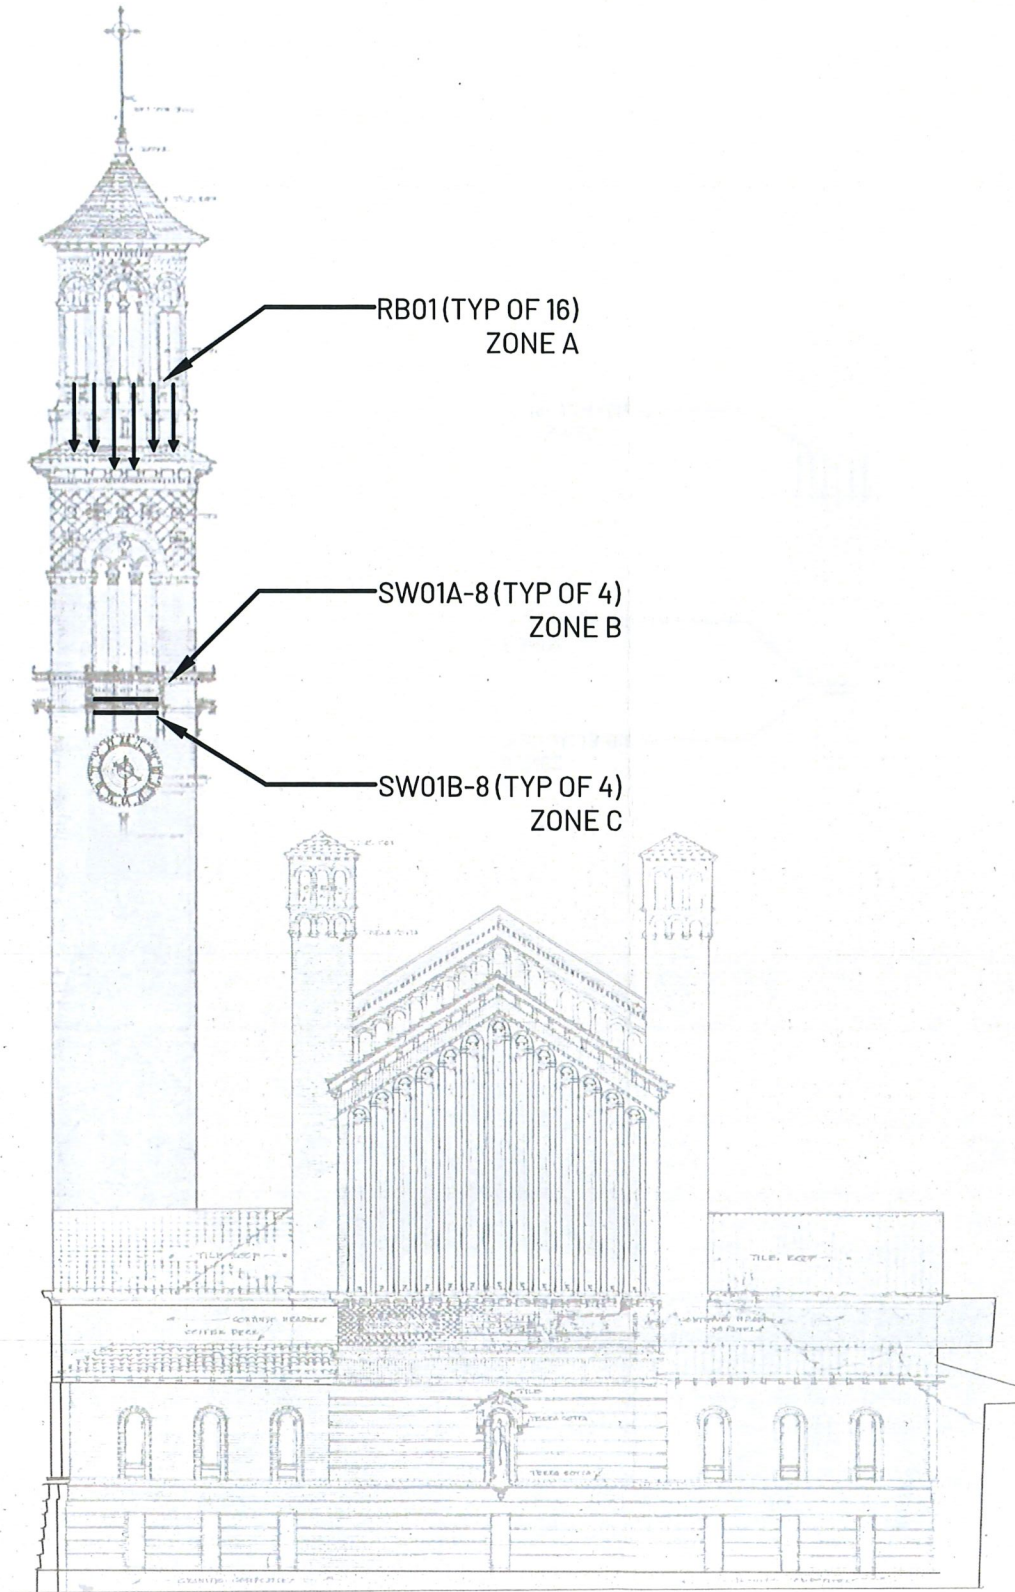

1
R2.04

SOUTH ELEVATION
SCALE: 3/32"=1'-0"

R2.04

SOUTH ELEVATION


Drawn
By: BDR

Checked
By: CHR

Date 15MARCH2025

V4

ST. PAUL'S PARISH
29 MT. AUBURN STREET CAMBRIDGE MA 02138
FACADE LIGHTING + CONTROLS UPGRADE

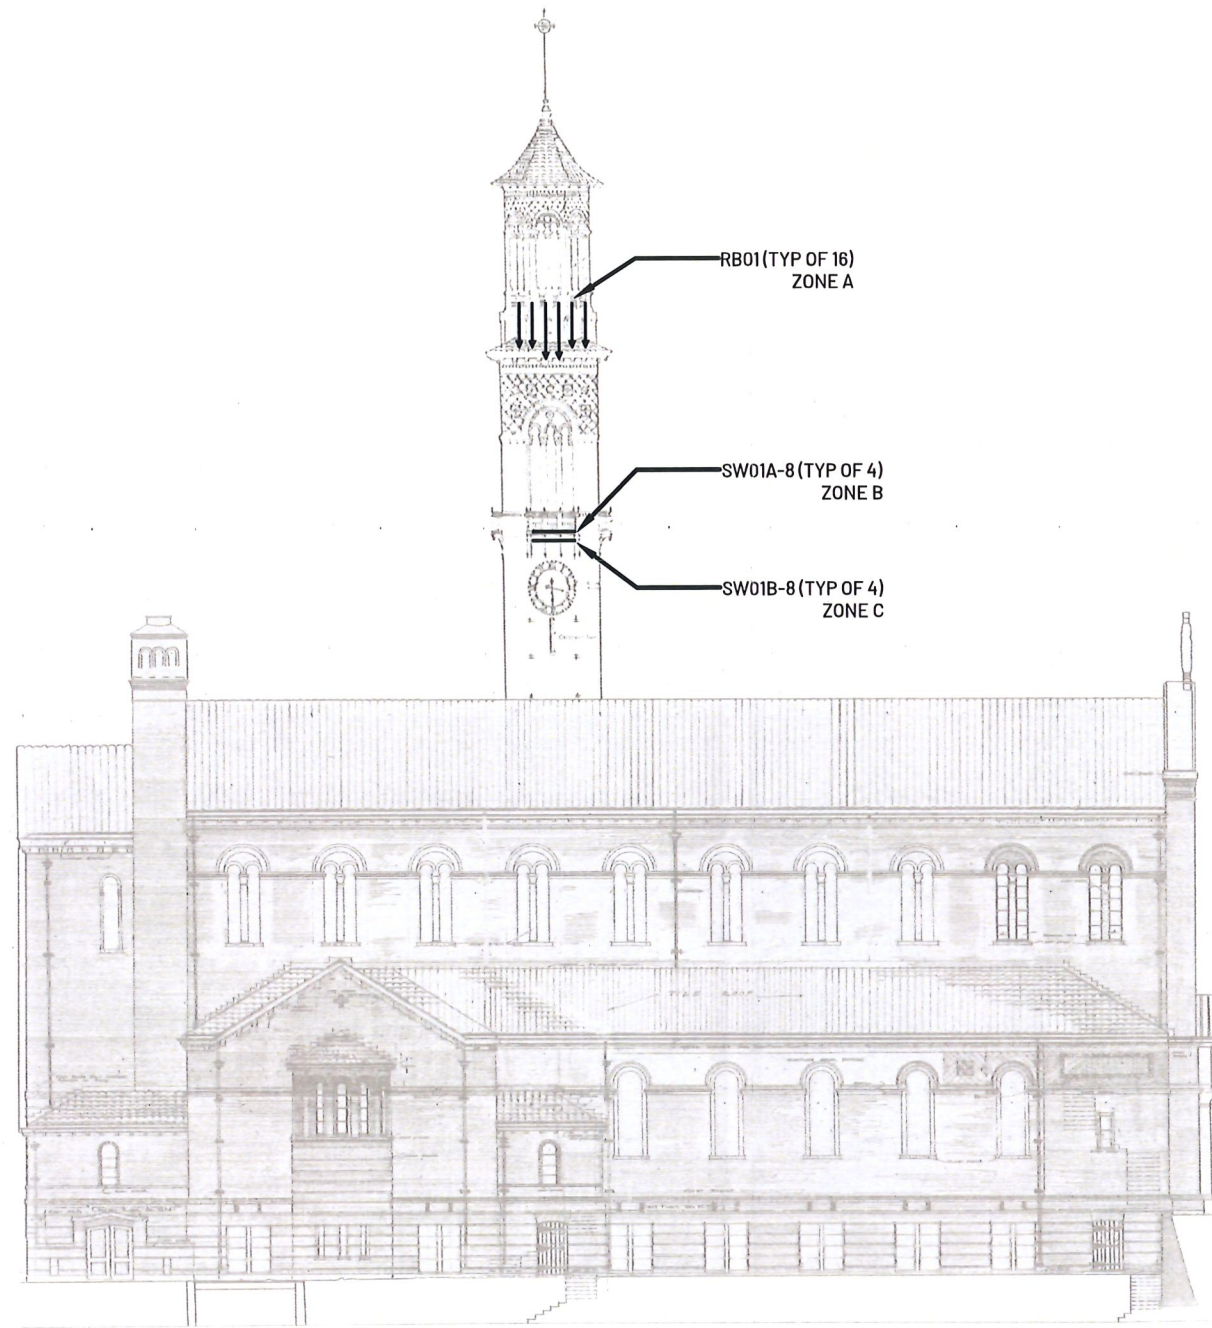

1 EAST ELEVATION
R2.05 SCALE: 1/16"=1'-0"

R2.05

EAST ELEVATION

Drawn
By: BDR

Checked
By: CHR

Date 15MARCH2025

V4

ST. PAUL'S PARISH
29 MT. AUBURN STREET CAMBRIDGE MA 02138
FACADE LIGHTING + CONTROLS UPGRADE

R2.06


WEST ELEVATION

Drawn
By: BDR

Checked
By: CHR


Date 15 MARCH 2025

V4

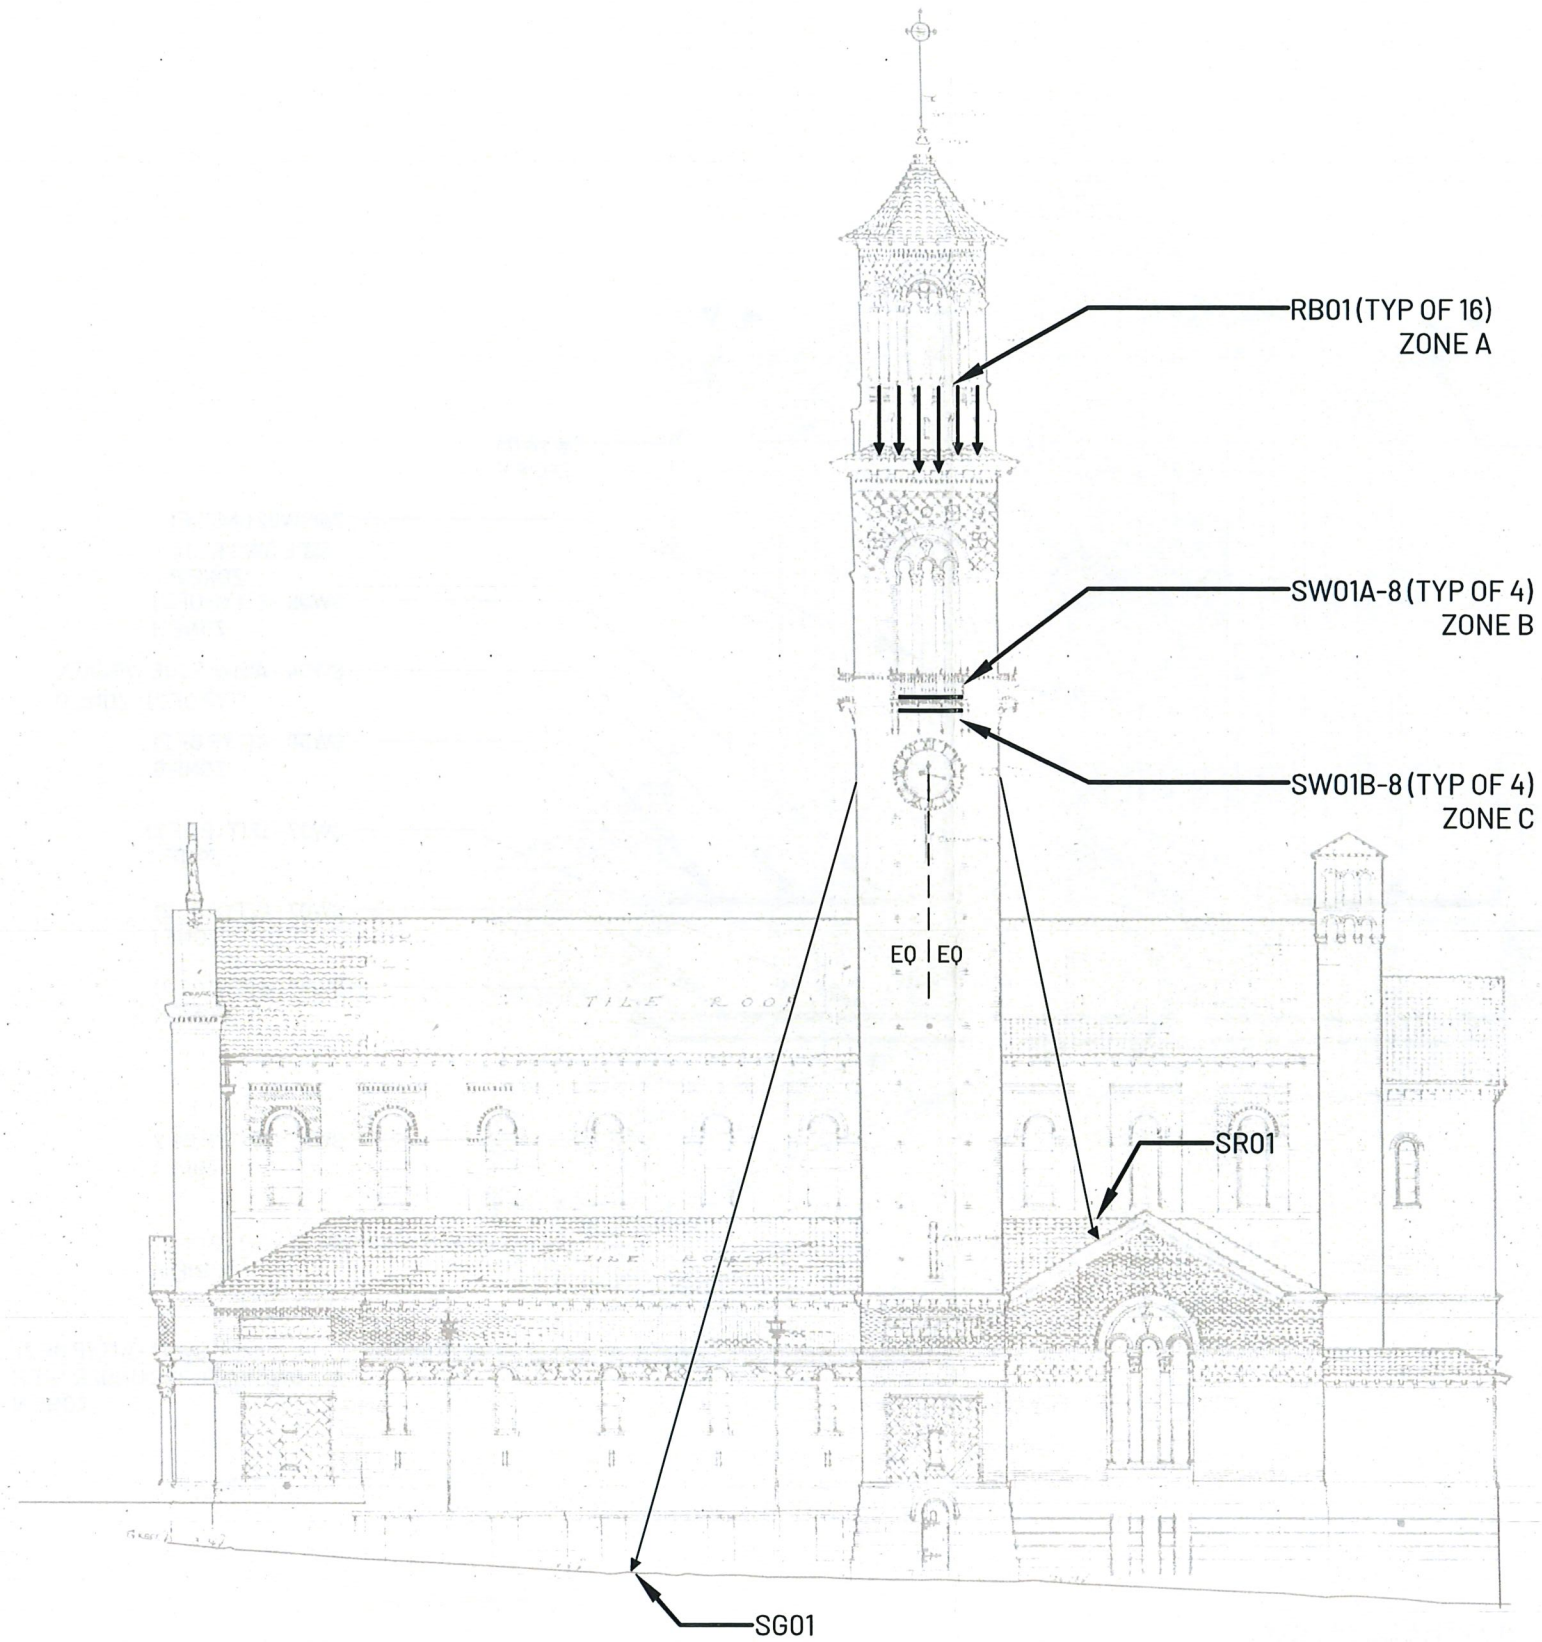

1 WEST ELEVATION
R2.06 SCALE: 3/32"=1'-0"

ST. PAUL'S PARISH
29 MT. AUBURN STREET CAMBRIDGE MA 02138
FACADE LIGHTING + CONTROLS UPGRADE

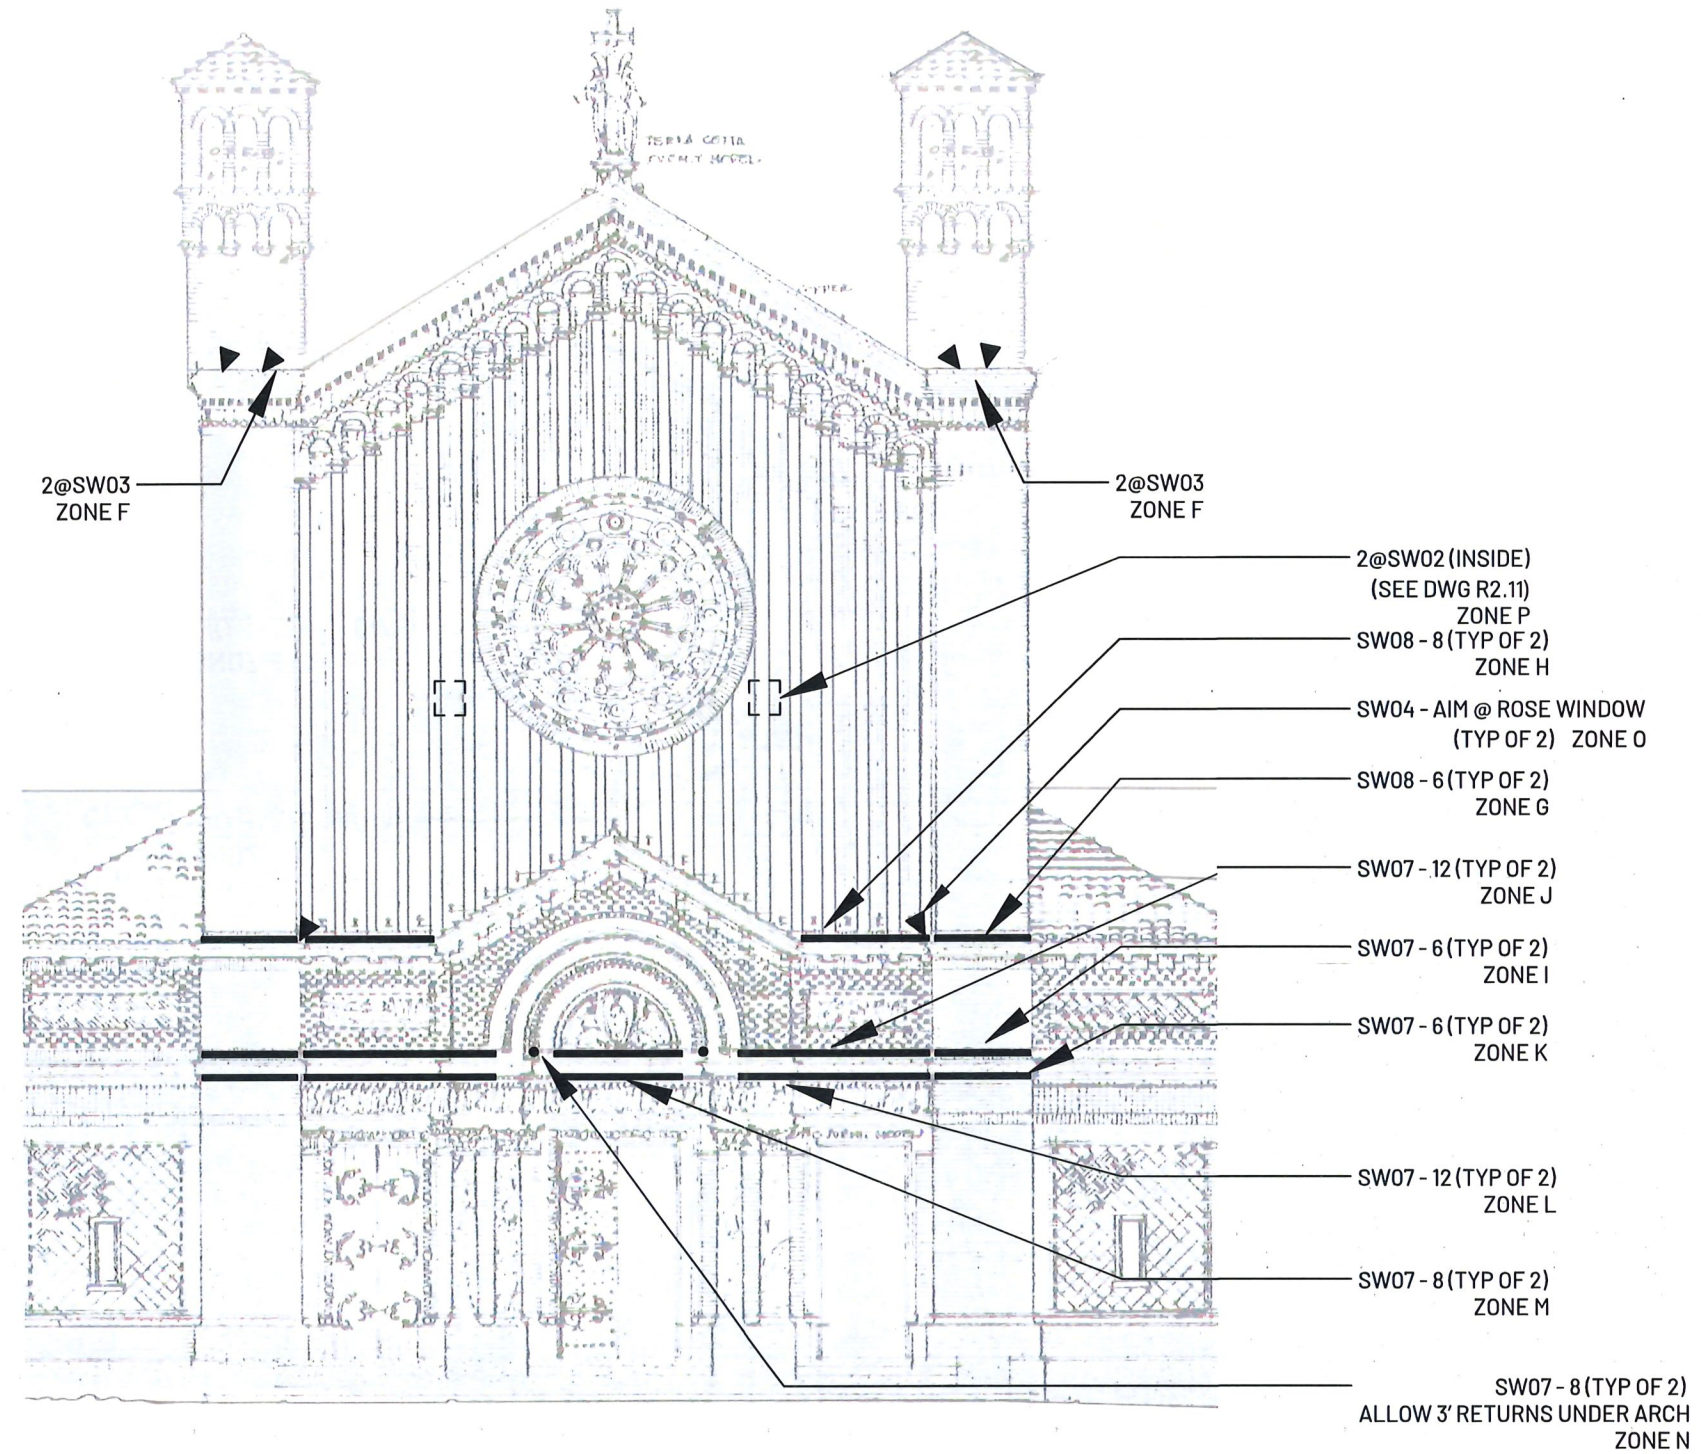

1
R2.07

NORTH ELEVATION
SCALE: 3/16"=1'-0"

0 1 2 5 10

R2.07


NORTH ELEVATION

Drawn
By: BDR

Checked
By: CHR

Date 15MARCH2025

V4

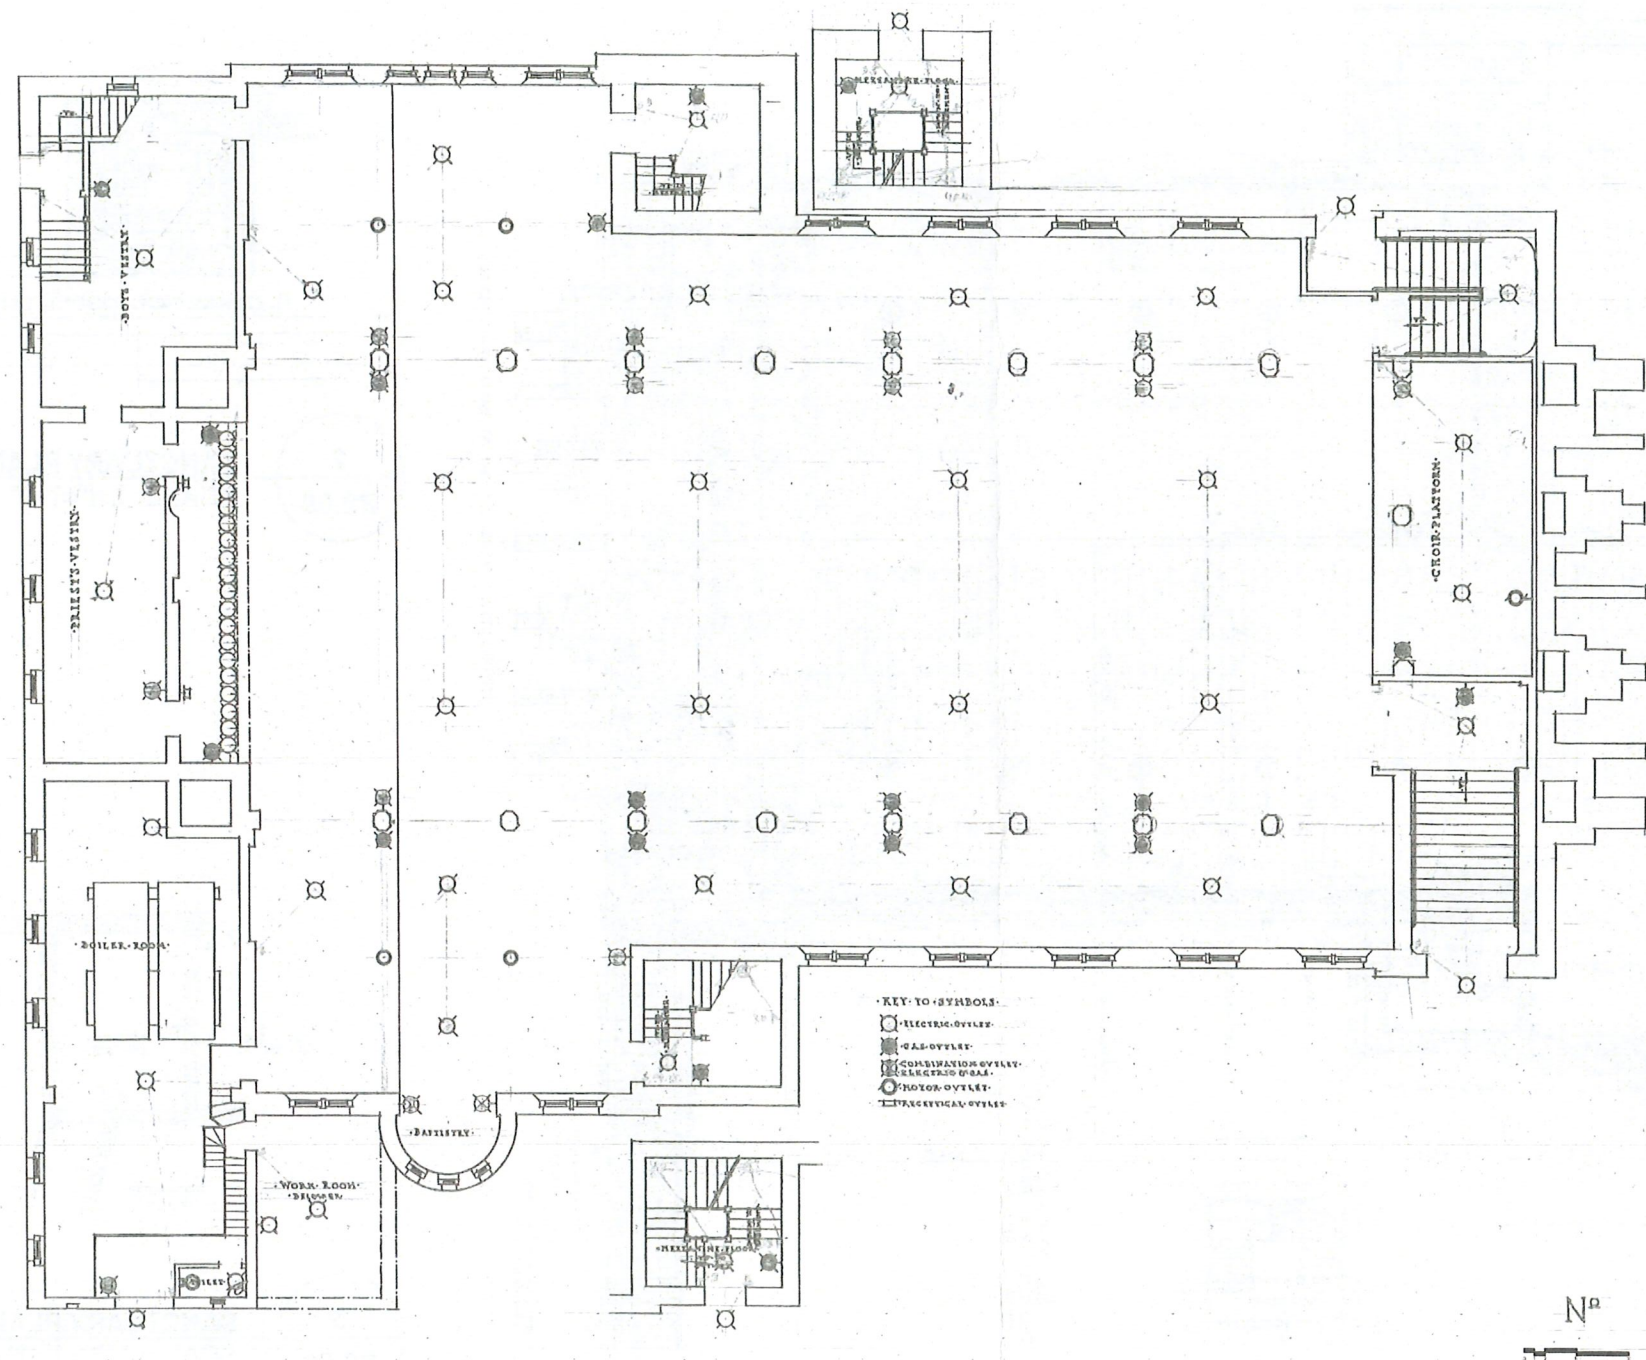

1
R2.08

SANCTUARY PLAN
SCALE: 1/8"=1'-0"

ST. PAUL'S PARISH
29 MT. AUBURN STREET CAMBRIDGE MA 02138
FACADE LIGHTING + CONTROLS UPGRADE

R2.08


SANCTUARY PLAN

Drawn
By: BDR

Checked
By: CHR

Date 15MARCH2025


V4

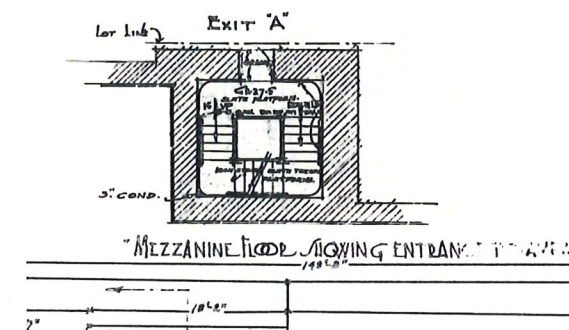

A hand-drawn architectural plan of a workshop. The main rectangular area is labeled "WORKSHOP CR. 12'5\"/>

3
R2.09 **SANCTUARY PLAN**
SCALE: 1/8"=1'-0"

ST. PAUL'S PARISH
29 MT. AUBURN STREET CAMBRIDGE MA 02138
FACADE LIGHTING + CONTROLS UPGRADE

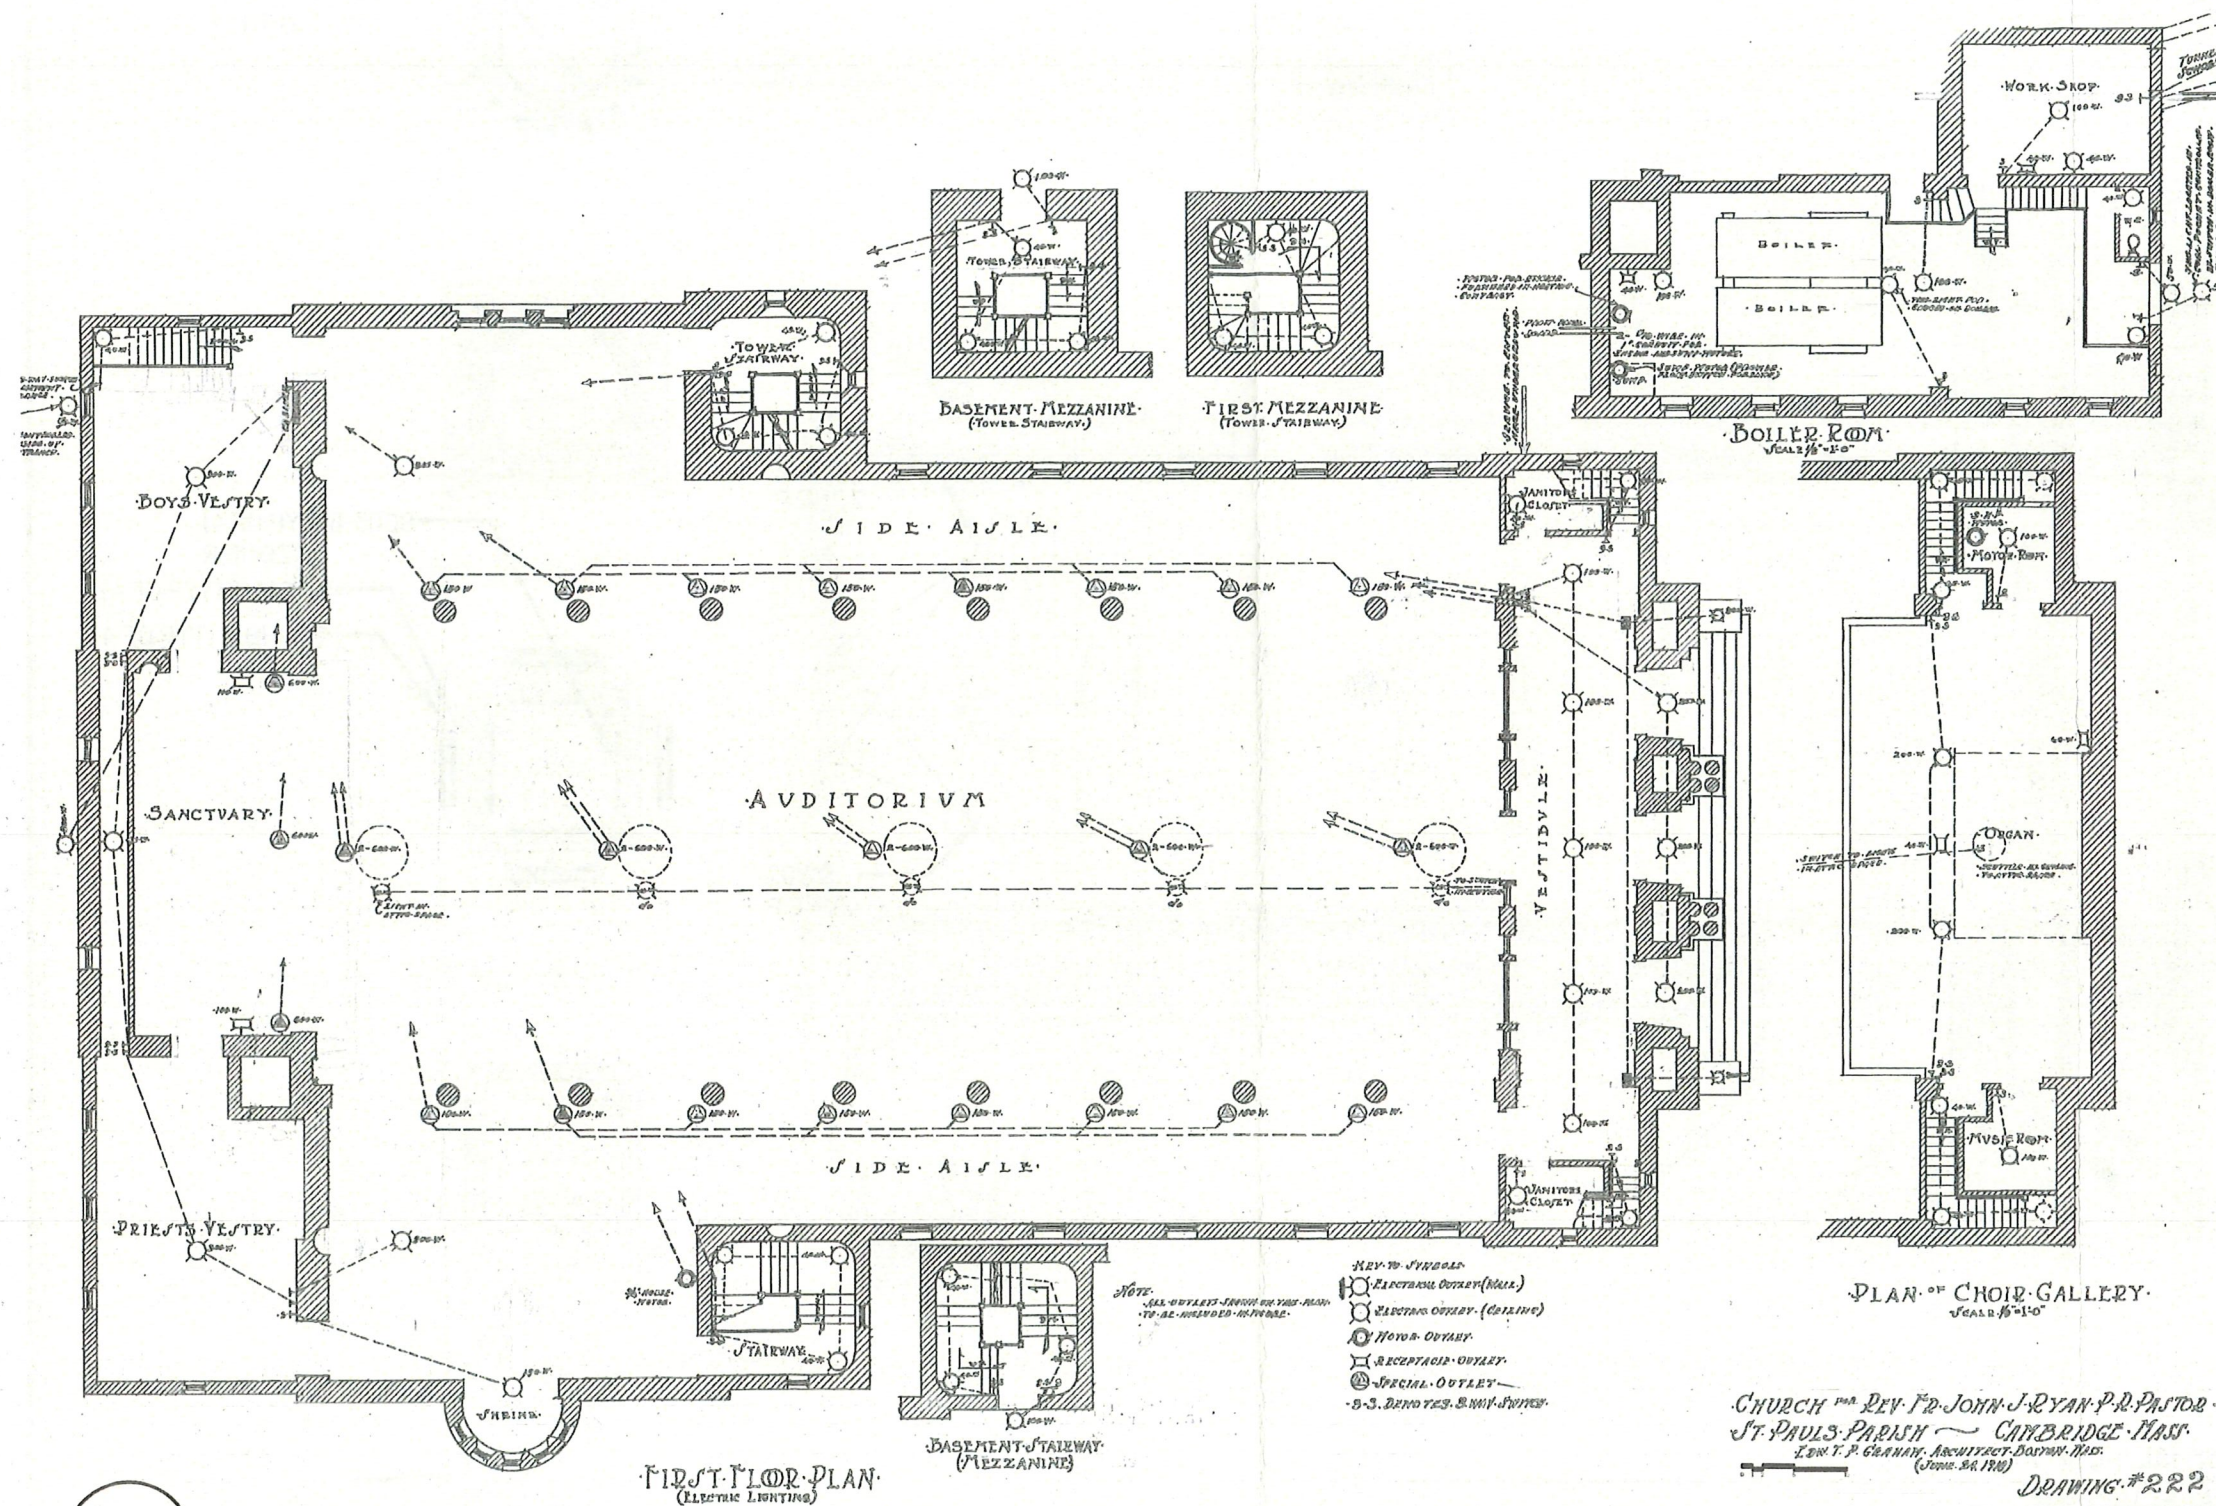

R2.10

BALCONY + TOWER
PLAN


Drawn
By: BDR

Checked
By: CHR

Date 15MARCH2025

V4

ST. PAUL'S PARISH
29 MT. AUBURN STREET CAMBRIDGE MA 02138
FACADE LIGHTING + CONTROLS UPGRADE

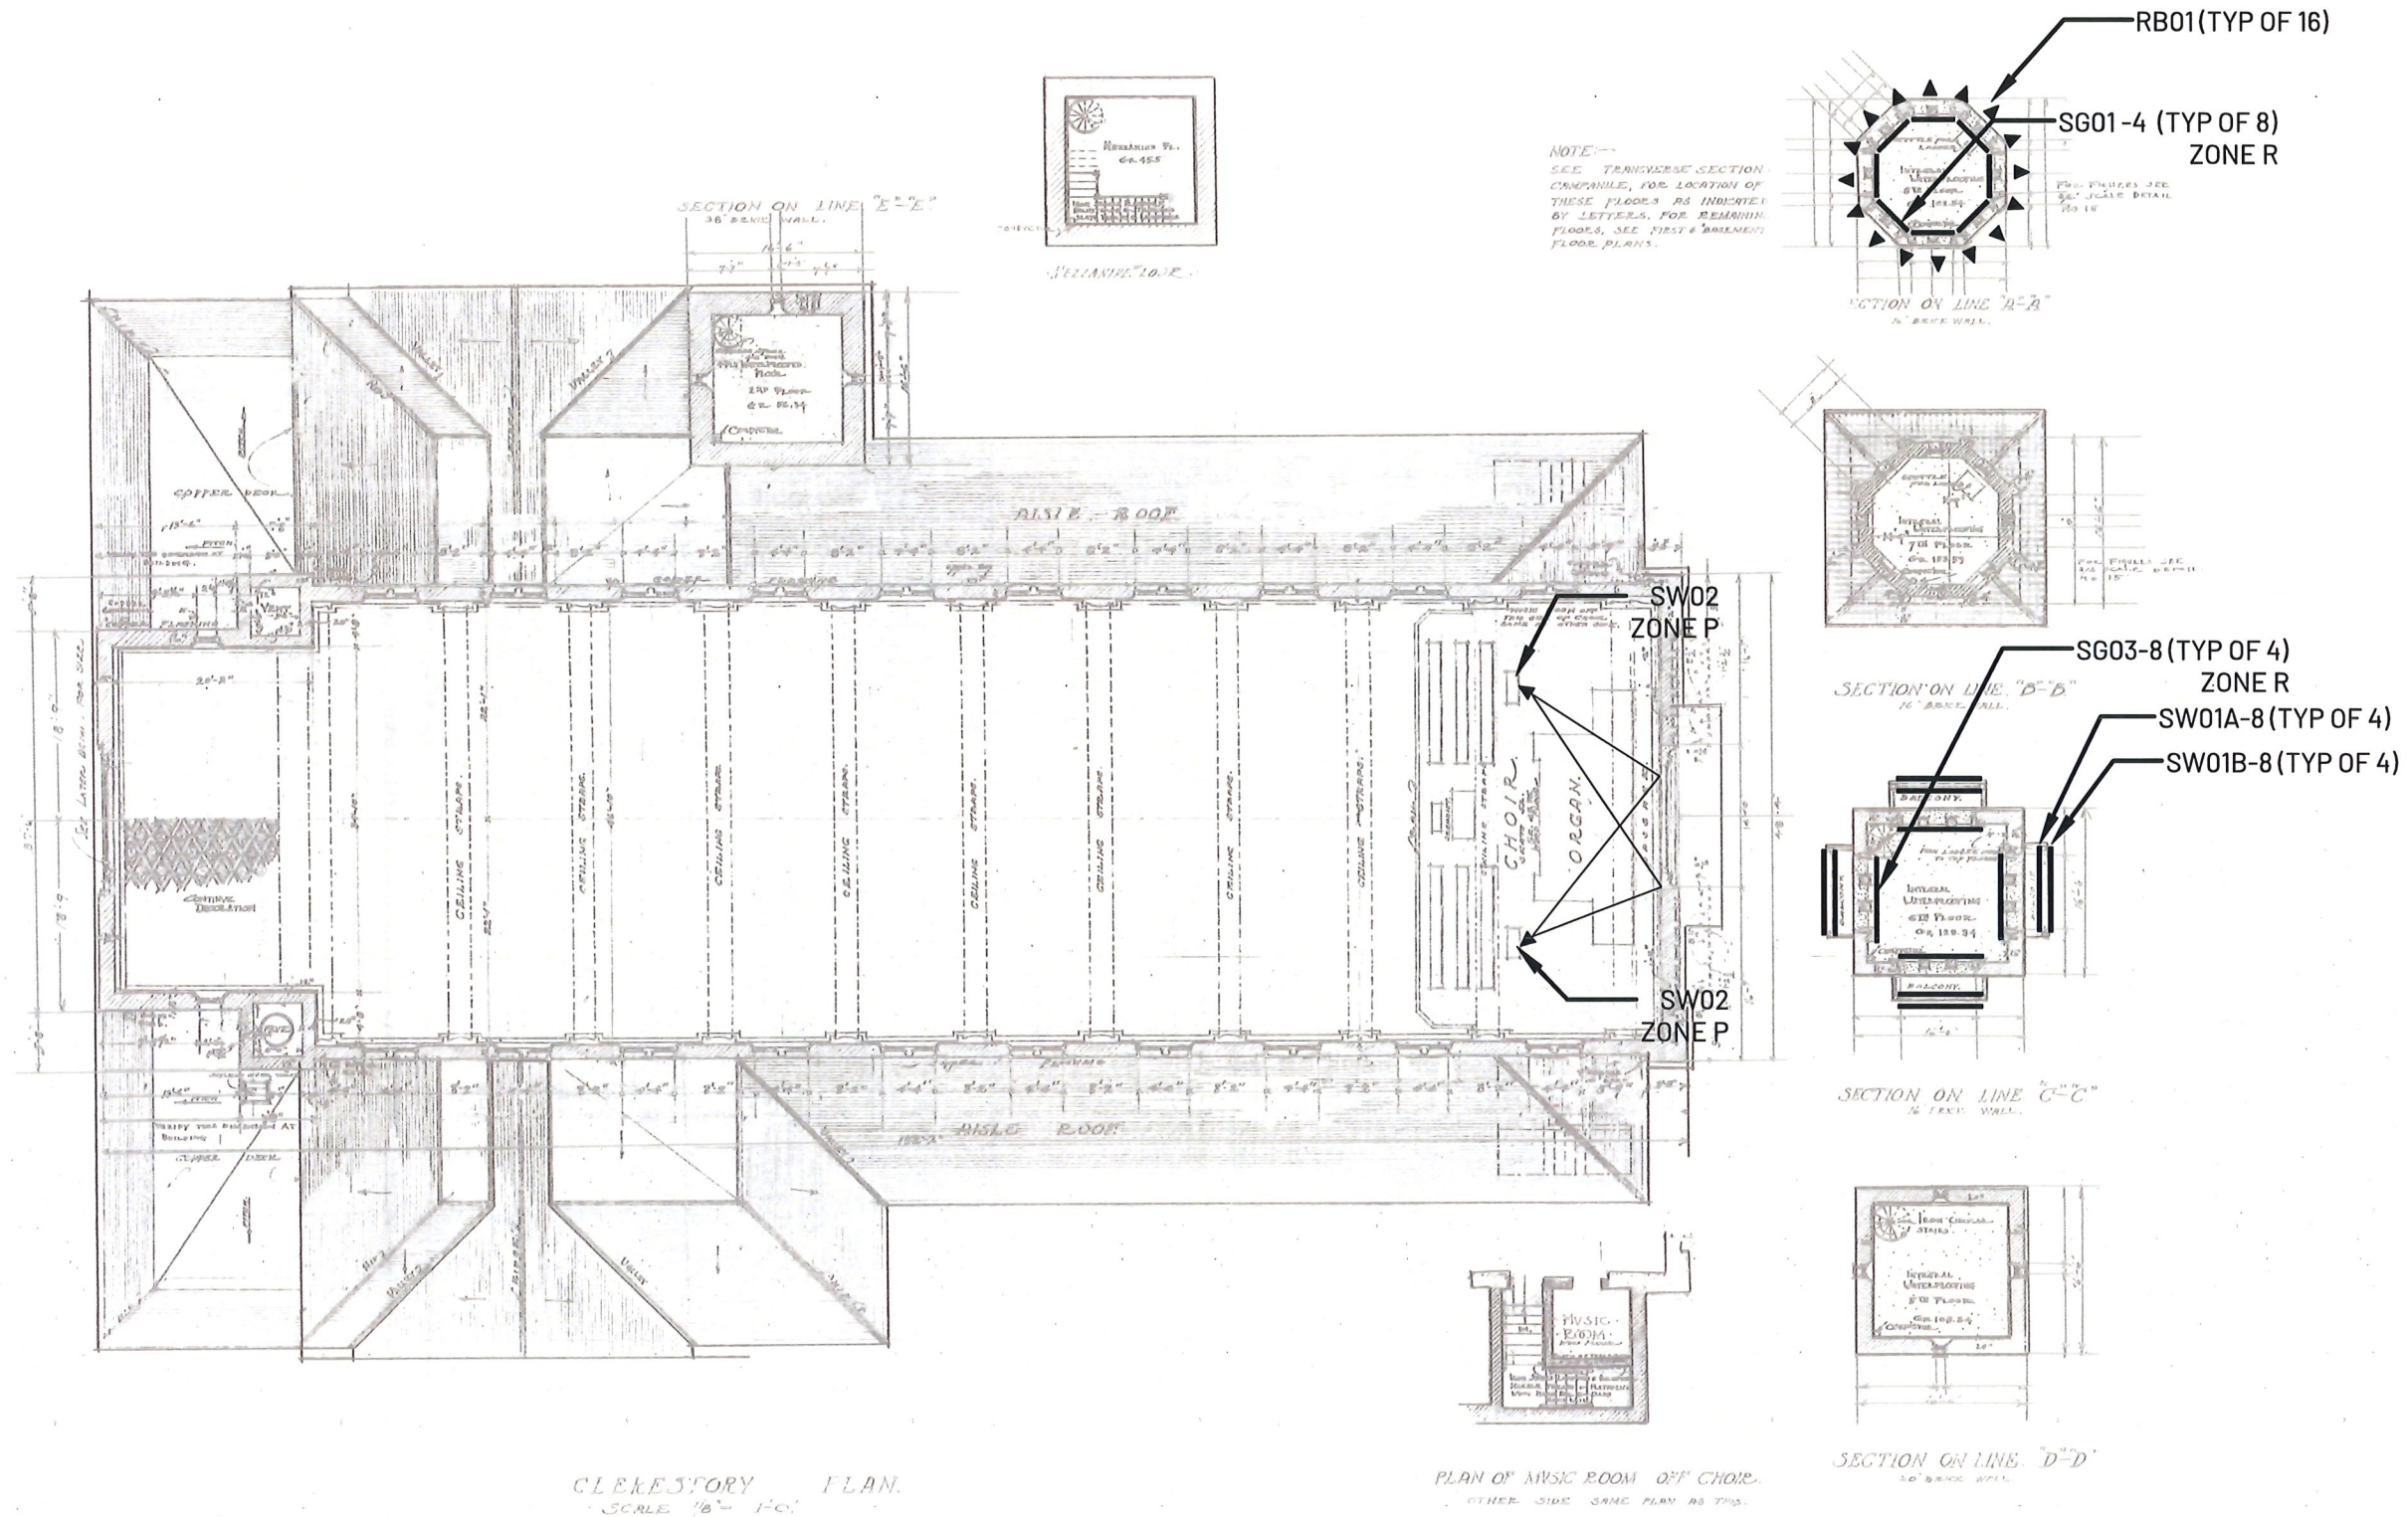

1
R2.11

PARTIAL ROOF PLAN
SCALE: 1/8"=1'-0"

R2.11


PARTIAL ROOF PLAN

Drawn By: BDR
Checked By: CHR

Date 15MARCH2025

V4

ST. PAUL'S PARISH
29 MT. AUBURN STREET CAMBRIDGE MA 02138
FACADE LIGHTING + CONTROLS UPGRADE

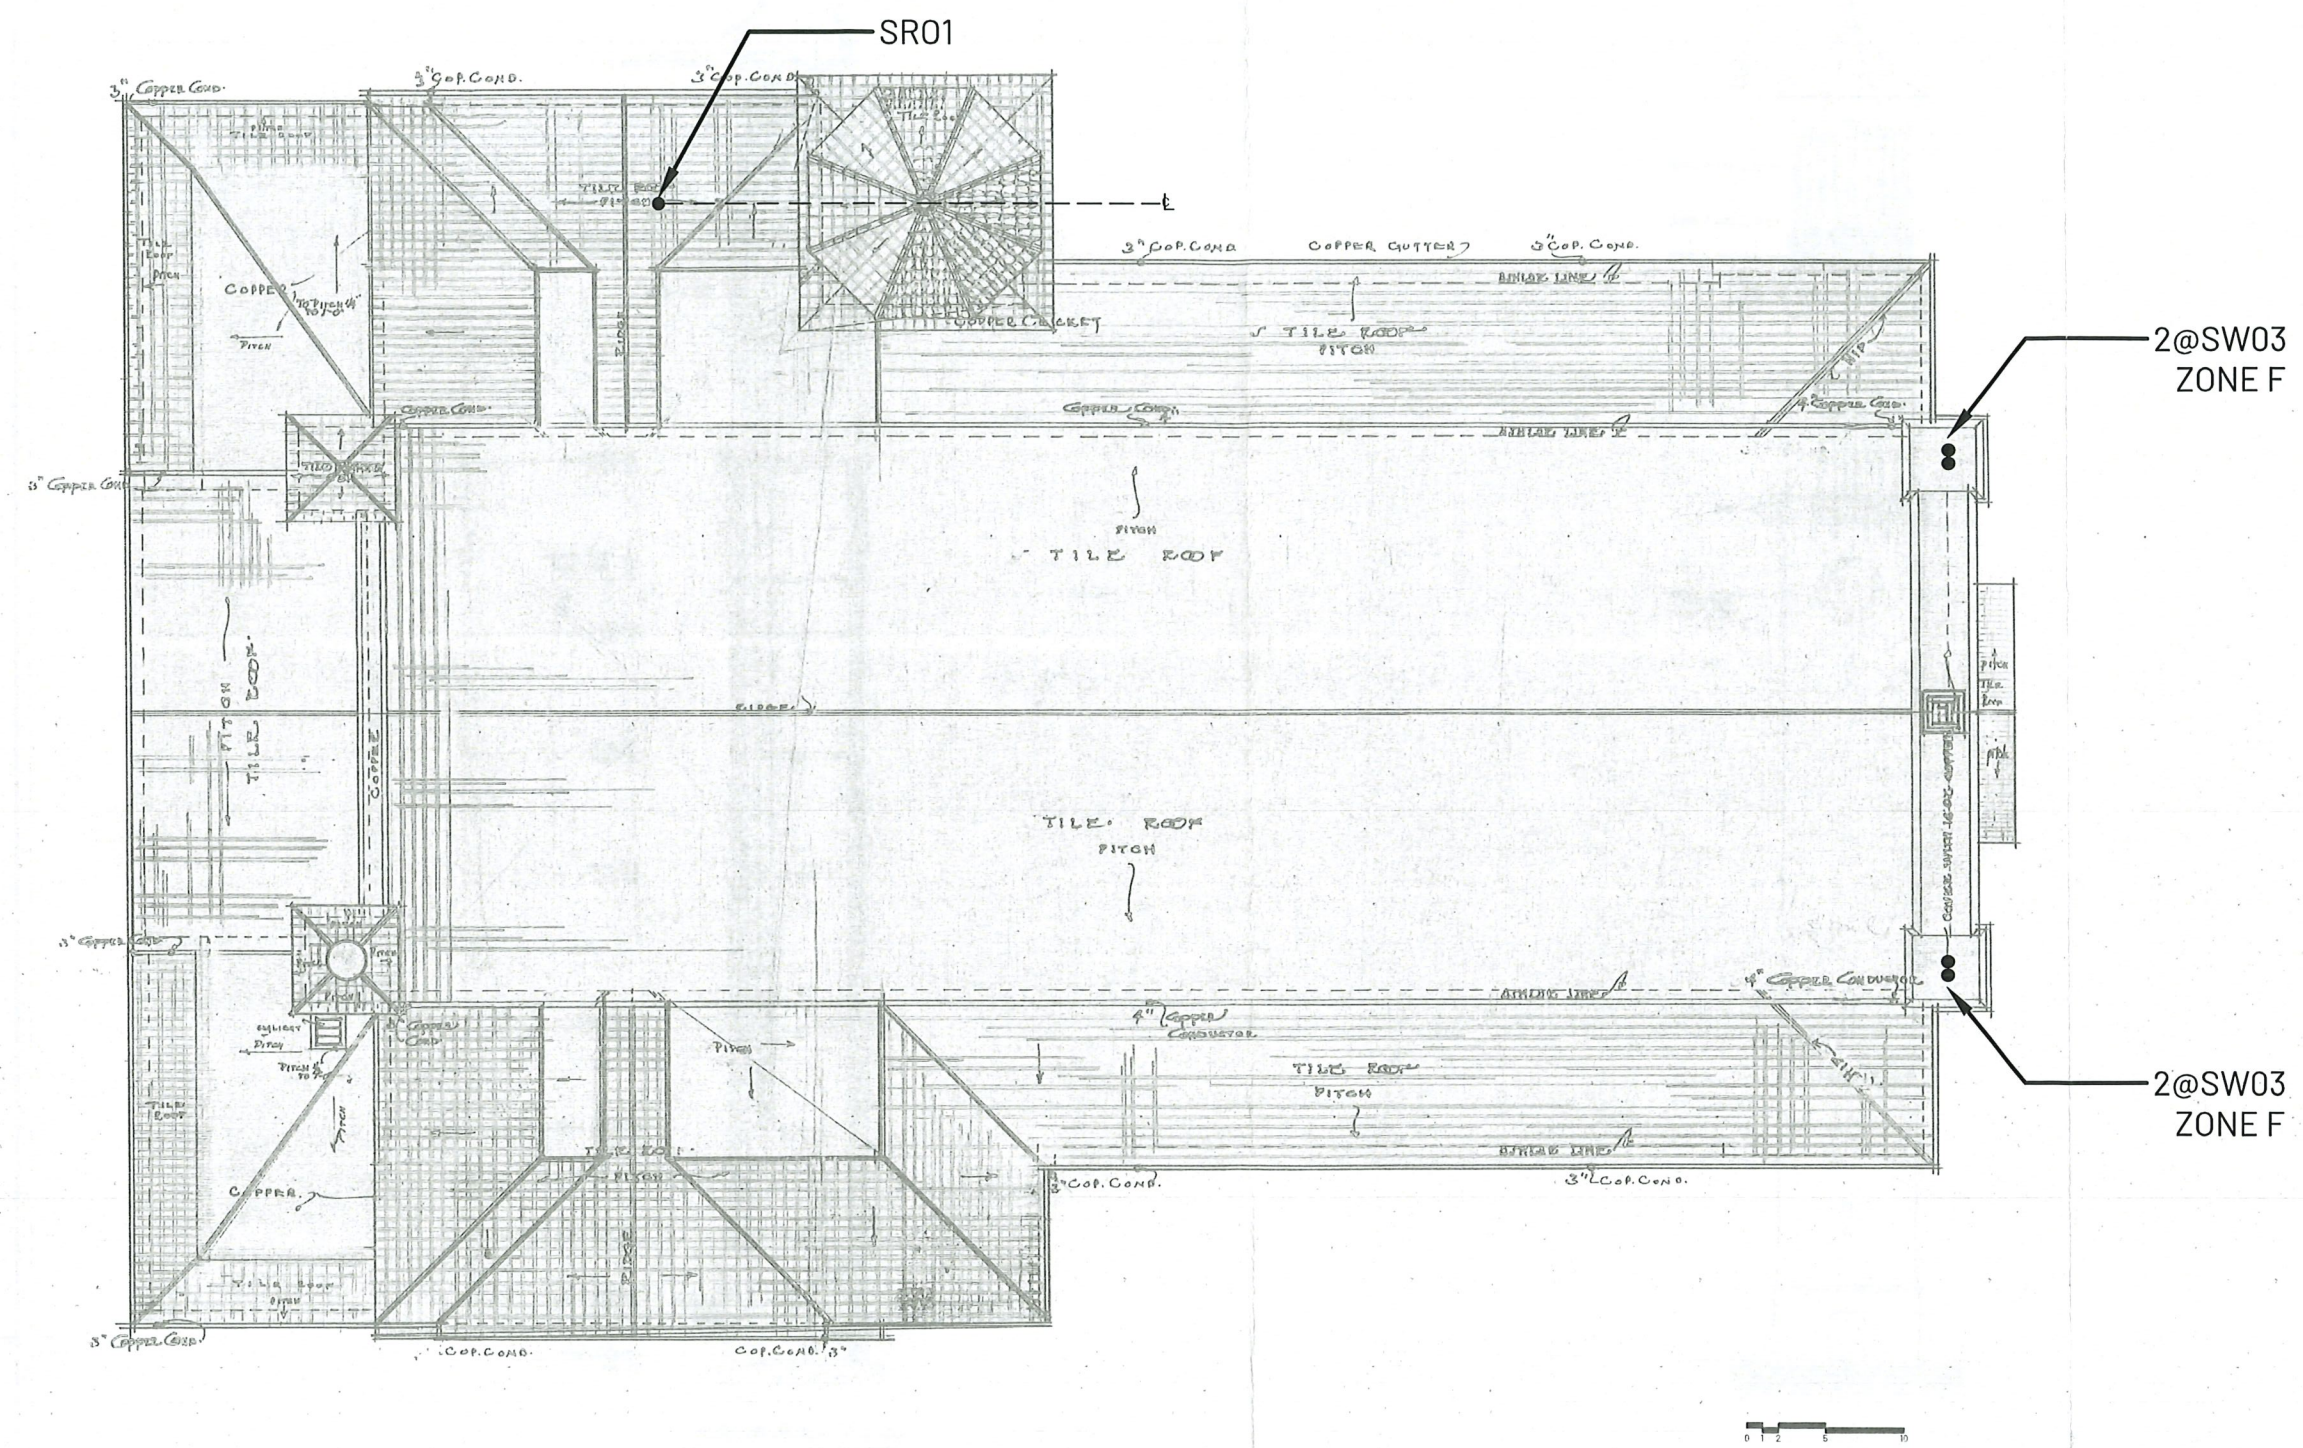

1
R2.12
ROOF PLAN
SCALE: 3/16"=1'-0"

R2.12

ROOF PLAN

Drawn By: BDR
Checked By: CHR

Date 15MARCH2025

V4



ST. PAUL'S PARISH
29 MT. AUBURN STREET CAMBRIDGE MA 02138
FACADE LIGHTING + CONTROLS UPGRADE

R2.14











TOWER PLAN DETAILS

Drawn
By: BDR

Checked
By: CHR

Date 15MARCH2025

V4

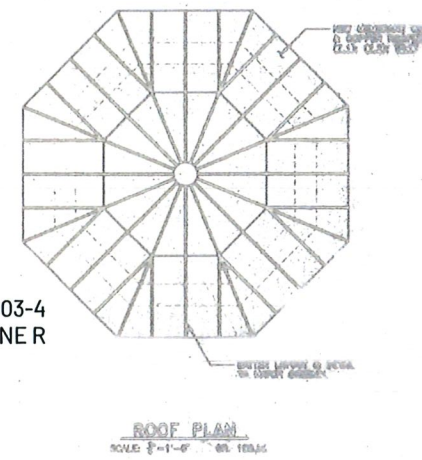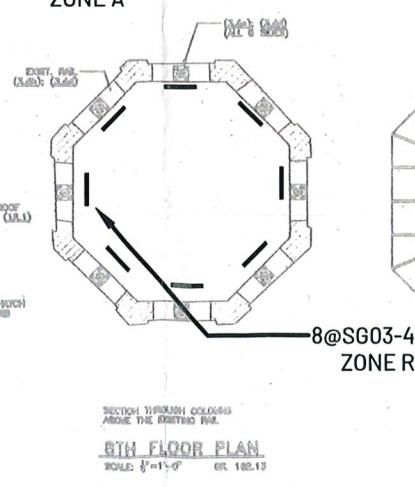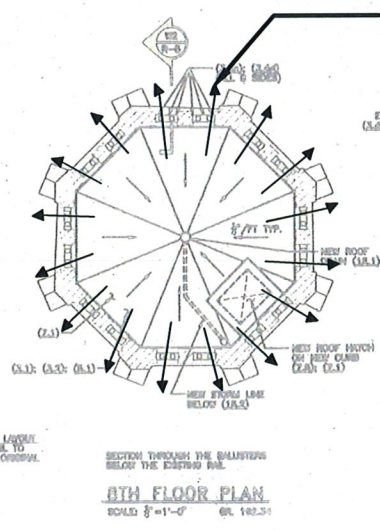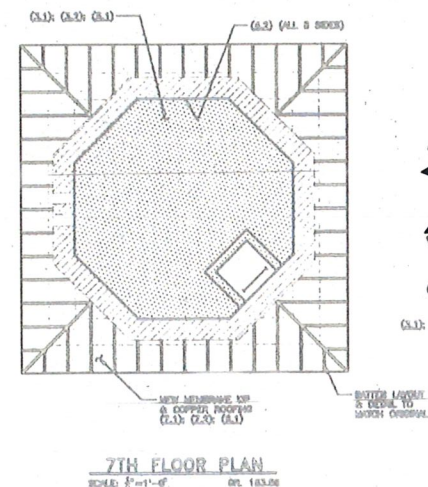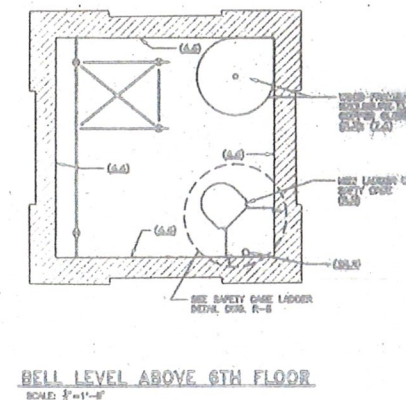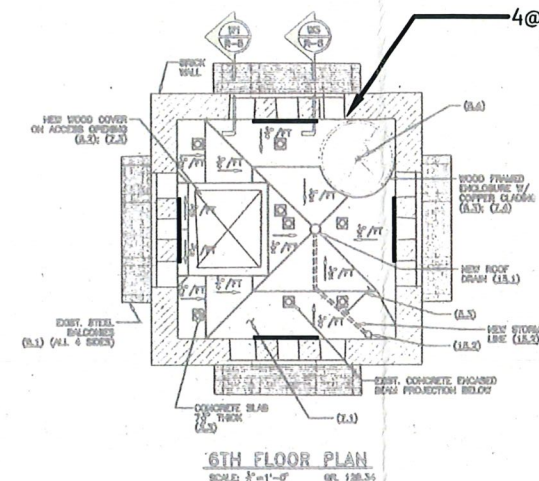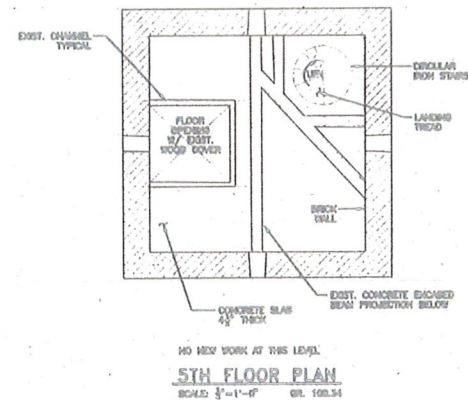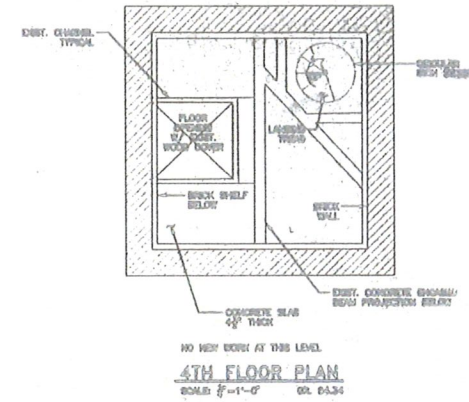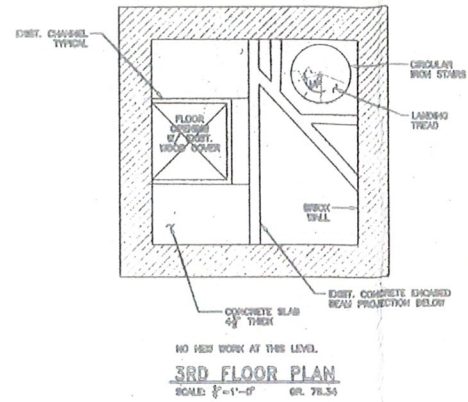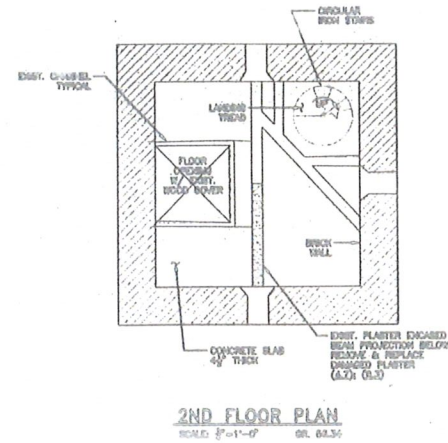

1
R2.13

TOWER PLAN DETAILS
SCALE: 3/32"=1'-0"

